


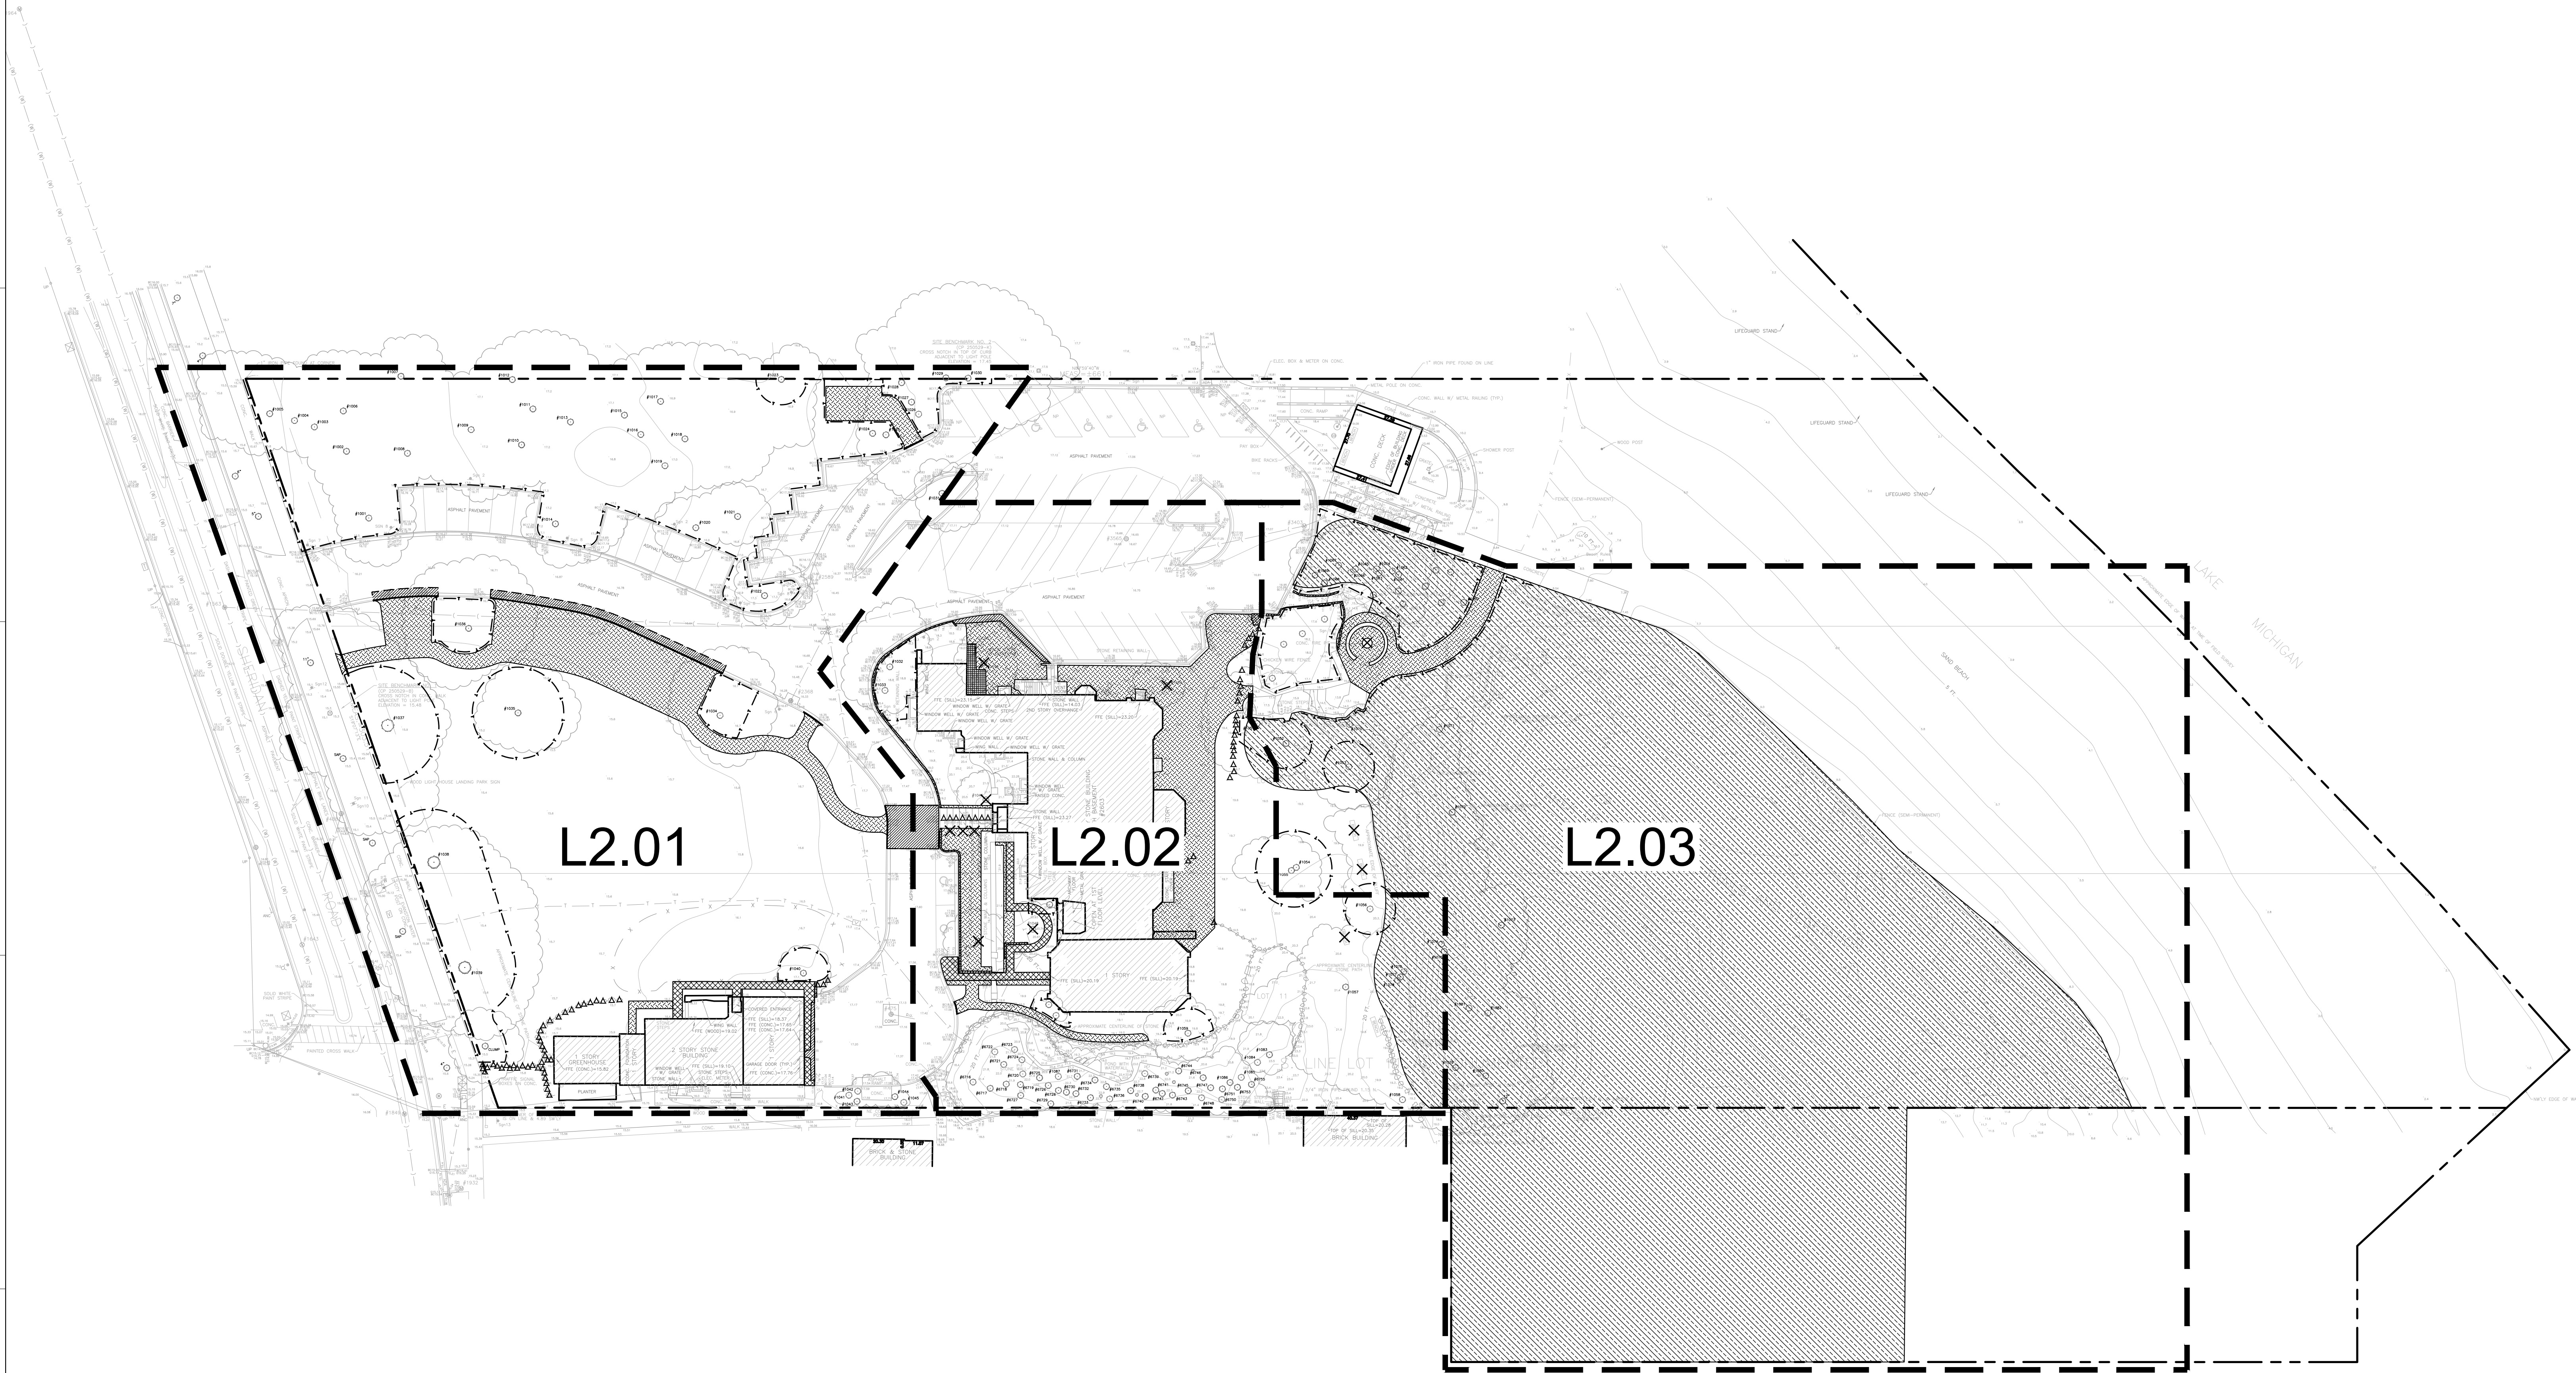


SITE PREPARATION AND REMOVALS NOTES

1. CONTRACTOR SHALL INSTALL CONSTRUCTION FENCE AT THE LIMITS OF CONSTRUCTION PRIOR TO BEGINNING WORK. MAINTAIN AND ADJUST CONSTRUCTION FENCING AS NEEDED DURING PROGRESS OF CONSTRUCTION.
2. CONTRACTOR SHALL IDENTIFY CONSTRUCTION STAGING AND ACCESS FOR APPROVAL BY OWNER PRIOR TO BEGINNING CONSTRUCTION UNLESS OTHERWISE SHOWN ON THE PLANS.
3. PLANS INDICATE GENERAL LOCATION AND LIMITS OF REMOVALS. LIMITS OF REMOVALS TO BE VERIFIED IN FIELD BY ARCHITECT. CONTRACTOR SHALL REMOVE ITEMS AS INDICATED. CONTRACTOR SHALL PERFORM REMOVALS ONLY AS NECESSARY FOR CONSTRUCTION OF PROPOSED IMPROVEMENTS. NO ADDITIONAL PAYMENTS WILL BE MADE FOR REMOVALS OR RESTORATION NOT REQUIRED TO CONSTRUCT THE IMPROVEMENTS AS DRAWN AND SPECIFIED. REFER TO LAYOUT PLAN FOR MORE SPECIFIC INFORMATION REGARDING PROPOSED IMPROVEMENTS AND VERIFY CONDITIONS IN THE FIELD PRIOR TO PERFORMING REMOVALS.
4. SAWCUT AND REMOVE CONCRETE PAVING TO NEAREST JOINT WHERE INDICATED. ALL SAW CUTS REQUIRED FOR REMOVAL ITEMS TO BE INCLUDED IN THE COST OF THAT PARTICULAR PAY ITEM.
5. TREE STUMPS SHALL BE GROUND TO A MINIMUM DEPTH OF 18 INCHES BELOW EXISTING GRADE OR AS REQUIRED TO PROPERLY PERFORM THE WORK.
6. REMOVE AND DISPOSE OF TURF WHERE PLANTING BEDS ARE DESIGNATED. REFER TO PLANTING PLAN FOR LIMITS OF PROPOSED LANDSCAPE IMPROVEMENTS.
7. REMOVE AND DISPOSE OF ALL BASE MATERIAL WHERE TURF OR PLANTINGS ARE PROPOSED IN EXISTING PAVED AREAS. REFER TO PLANTING PLAN FOR LIMITS OF PROPOSED LANDSCAPE IMPROVEMENTS.
8. REMOVE ALL UTILITIES DESIGNATED FOR REMOVAL TO EXTENT REQUIRED FOR IMPROVEMENTS, UNLESS OTHERWISE SHOWN ON THE PLANS. CAP ENDS OF ANY REMAINING UNDERGROUND CONDUIT AND PIPING, AND PULL ALL ELECTRICAL WIRE OUT AT SOURCE.
9. ITEMS INDICATED FOR REMOVAL SHALL INCLUDE COMPLETE REMOVAL OF ABOVE GRADE ITEM AND BELOW GRADE APPURTANCES (FOUNDATIONS, WIRING, PIPING, ETC.) INCLUDING DISPOSAL OFF-SITE FOLLOWING APPLICABLE CODES AND ORDINANCES, UNLESS OTHERWISE SHOWN ON THE PLANS.
10. ITEMS INDICATED AS REMOVE AND SALVAGE SHALL INCLUDE CAREFUL PROTECTION, REMOVAL, AND STORAGE OF ITEMS. FOR REINSTALL ITEMS, CONTRACTOR SHALL STORE DURING CONSTRUCTION. ALL OTHER SALVAGE ITEMS SHALL BE DELIVERED TO LOCATION AS INDICATED BY OWNER UNLESS OTHERWISE SHOWN ON THE PLANS.
11. CONTRACTOR SHALL BE RESPONSIBLE FOR THE REPAIR OF ANY DEEP RUTTING AND EROSION CAUSED BY THE CONTRACTOR AND MACHINE ACTIVITIES.
12. CONTRACTOR TO PROTECT ALL EXISTING UTILITIES AND ALL OTHER SITE FEATURES NOT DESIGNATED FOR REMOVAL. CONTRACTOR IS RESPONSIBLE FOR REPLACING/REPAIRING ANY EXISTING UTILITIES OR OTHER SITE FEATURES DAMAGED DURING CONSTRUCTION TO THE ORIGINAL CONDITION AT NO COST TO THE OWNER.
13. CONTRACTOR RESPONSIBLE FOR MAINTAINING EXISTING UTILITY SERVICES (ELECTRICAL, SANITARY, STORM) DURING CONSTRUCTION UNLESS OTHERWISE SHOWN ON THE PLANS.
14. CONTRACTOR SHALL COORDINATE ALL WORK SO PUBLIC SIDEWALK REMAINS OPEN THROUGHOUT CONSTRUCTION UNLESS OTHERWISE SHOWN ON THE PLANS.
15. REFER TO ARCHITECTURE, CIVIL, AND ELECTRICAL PLANS FOR ADDITIONAL UTILITY ADJUSTMENTS AND REMOVALS.
16. REFER TO SPECIFICATIONS FOR ADDITIONAL CONDITIONS, STANDARDS AND NOTES.

SITE PREPARATION AND REMOVALS LEGEND

- | | |
|--|---|
| | REMOVE AND DISPOSE OF CONCRETE PAVING AND GRAVEL BASE. REMOVE SUBGRADE MATERIAL AS NEEDED. |
| | REMOVE AND DISPOSE OF ASPHALT PAVING AND GRAVEL BASE. REMOVE SUBGRADE MATERIAL AS NEEDED. |
| | REMOVE AND SALVAGE STONE WALLS, STEPS, AND PAVING. REMOVE SUBGRADE MATERIAL AS NEEDED. |
| | REMOVE LAWN AND MISCELLANEOUS SUBGRADE MATERIAL AS NEEDED. |
| | REMOVE ALL EXOTIC, INVASIVE, AND UNDESIRABLE PLANT SPECIES AS NOTED BY LANDSCAPE ARCHITECT. |
| | REMOVE WOOD DECK, POSTS, FOUNDATIONS AND BASE MATERIAL. REMOVE SUBGRADE MATERIAL AS NEEDED. |
| | TREE PROTECTION FENCE |
| | ITEM TO BE RELOCATED |
| | ITEM TO BE REMOVED |
| | CURB TO BE REMOVED |
| | LIMIT OF SAWCUT |
| | SILT FENCE |
| | CONSTRUCTION FENCE |
| | FENCE REMOVAL |
| | PROJECT LIMIT LINE |

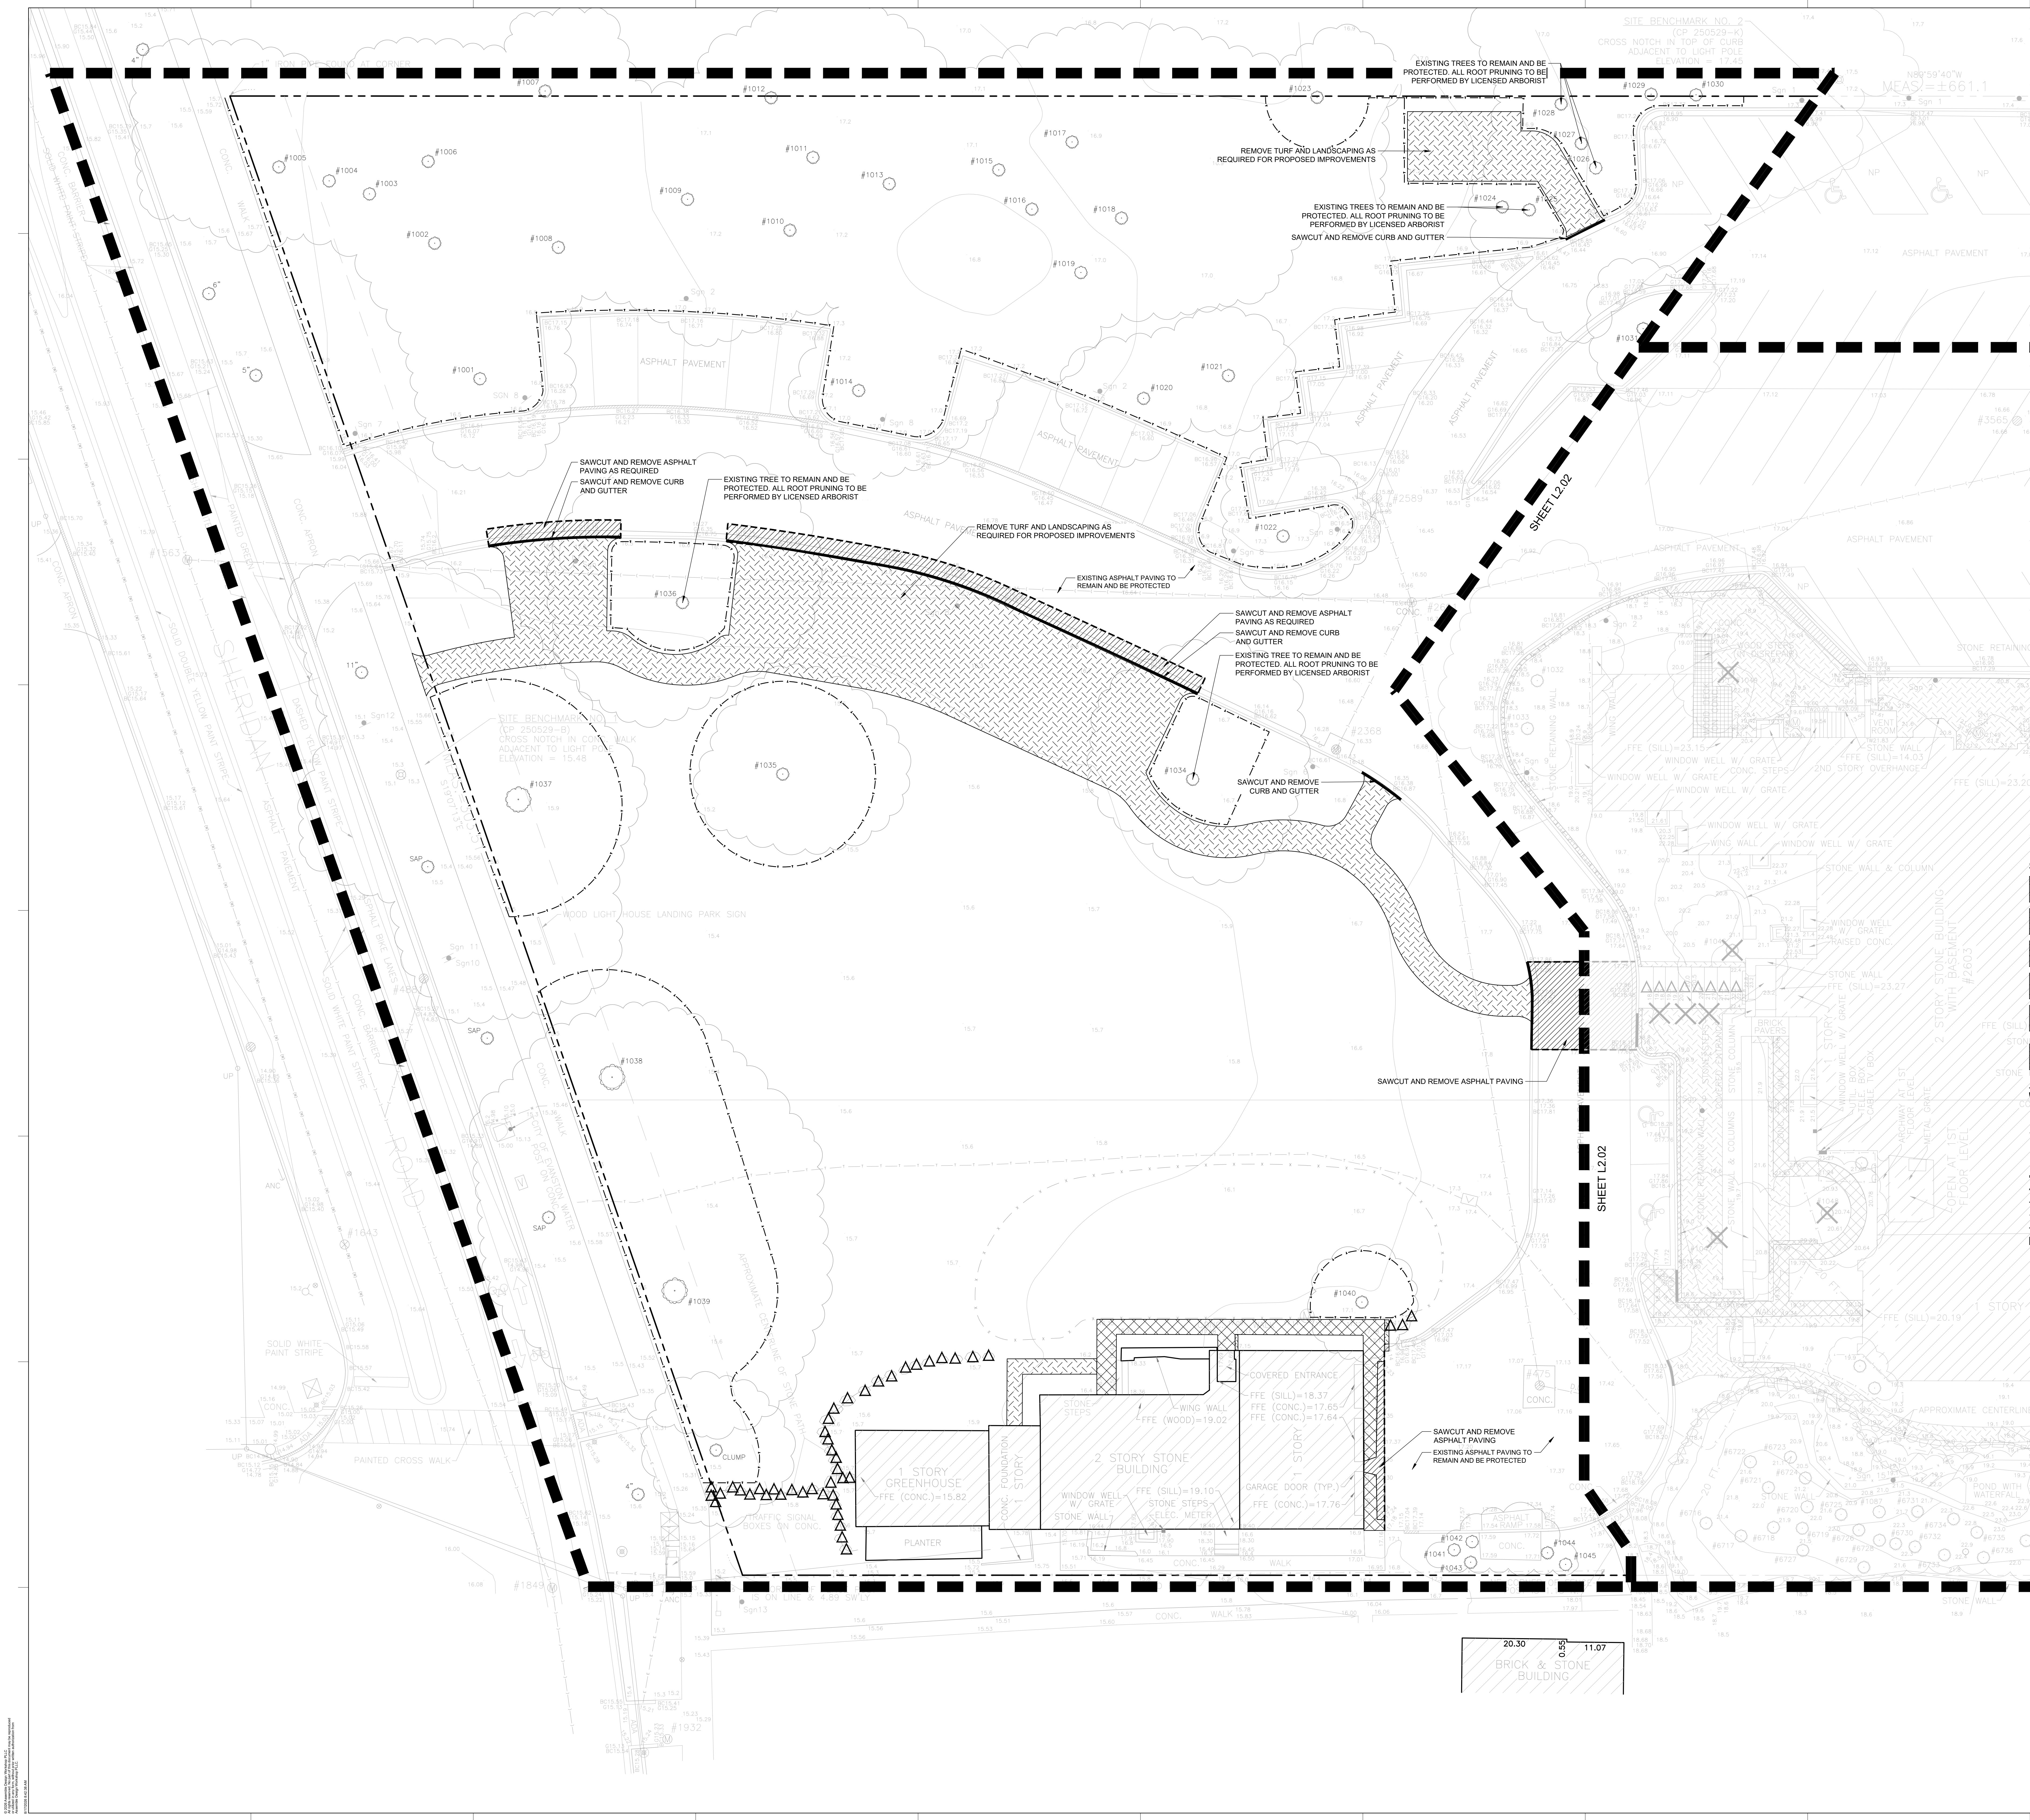

- ### SITE PREPARATION AND REMOVALS NOTES
1. CONTRACTOR SHALL INSTALL CONSTRUCTION FENCE AT THE LIMITS OF REMOVALS TO BE VERIFIED IN FIELD BY ARCHITECT. MAINTAIN AND ADJUST CONSTRUCTION FENCING AS NEEDED DURING PROGRESS OF CONSTRUCTION.
 2. CONTRACTOR SHALL IDENTIFY CONSTRUCTION STAGING AND ACCESS FOR APPROVAL BY OWNER PRIOR TO BEGINNING CONSTRUCTION UNLESS OTHERWISE SHOWN ON THE PLANS.
 3. PLANS INDICATE GENERAL LOCATION AND LIMITS OF REMOVALS. LIMITS OF REMOVALS TO BE VERIFIED IN FIELD BY ARCHITECT. CONTRACTOR SHALL REMOVE ITEMS AS INDICATED. CONTRACTOR SHALL PERFORM REMOVALS ONLY AS NECESSARY FOR CONSTRUCTION OF PROPOSED IMPROVEMENTS. NO ADDITIONAL PAYMENTS WILL BE MADE FOR REMOVALS OR RESTORATION NOT REQUIRED TO CONSTRUCT THE IMPROVEMENTS AS DRAWN AND SPECIFIED. REFER TO LAYOUT PLAN FOR MORE SPECIFIC INFORMATION REGARDING PROPOSED IMPROVEMENTS AND VERIFY CONDITIONS IN THE FIELD PRIOR TO PERFORMING REMOVALS.
 4. SAWCUT AND REMOVE CONCRETE PAVING TO NEAREST JOINT WHERE INDICATED. ALL SAW CUTS REQUIRED FOR REMOVAL ITEMS TO BE INCLUDED IN THE COST OF THAT PARTICULAR PAY ITEM.
 5. TREE STUMPS SHALL BE GROUND TO A MINIMUM DEPTH OF 18 INCHES BELOW EXISTING GRADE OR AS REQUIRED TO PROPERLY PERFORM THE WORK.
 6. REMOVE AND DISPOSE OF TURF WHERE PLANTING BEDS ARE DESIGNATED. REFER TO PLANTING PLAN FOR LIMITS OF PROPOSED LANDSCAPE IMPROVEMENTS.
 7. REMOVE AND DISPOSE OF ALL BASE MATERIAL WHERE TURF OR PLANTINGS ARE PROPOSED IN EXISTING PAVED AREAS. REFER TO PLANTING PLAN FOR LIMITS OF PROPOSED LANDSCAPE IMPROVEMENTS.
 8. REMOVE ALL UTILITIES DESIGNATED FOR REMOVAL TO EXTENT REQUIRED FOR IMPROVEMENTS, UNLESS OTHERWISE SHOWN ON THE PLANS. CAP ENDS OF ANY REMAINING UNDERGROUND CONDUIT AND PIPING, AND PULL ALL ELECTRICAL WIRE OUT AT SOURCE.
 9. ITEMS INDICATED FOR REMOVAL SHALL INCLUDE COMPLETE REMOVAL OF ABOVE GRADE ITEM AND BELOW GRADE APPURTENANCES (FOUNDATIONS, WIRING, PIPING, ETC.) INCLUDING DISPOSAL OFF-SITE FOLLOWING APPLICABLE CODES AND ORDINANCES, UNLESS OTHERWISE SHOWN ON THE PLANS.
 10. ITEMS INDICATED AS REMOVE AND SALVAGE SHALL INCLUDE CAREFUL PROTECTION, REMOVAL, AND STORAGE OF ITEMS. FOR REINSTALL ITEMS, CONTRACTOR SHALL STORE DURING CONSTRUCTION. ALL OTHER SALVAGE ITEMS SHALL BE DELIVERED TO LOCATION AS INDICATED BY OWNER UNLESS OTHERWISE SHOWN ON THE PLANS.
 11. CONTRACTOR SHALL BE RESPONSIBLE FOR THE REPAIR OF ANY DEEP RUTTING AND EROSION CAUSED BY THE CONTRACTOR AND MACHINE ACTIVITIES.
 12. CONTRACTOR TO PROTECT ALL EXISTING UTILITIES AND ALL OTHER SITE FEATURES NOT DESIGNATED FOR REMOVAL. CONTRACTOR IS RESPONSIBLE FOR REPLACING/REPAIRING ANY EXISTING UTILITIES OR OTHER SITE FEATURES DAMAGED DURING CONSTRUCTION TO THE ORIGINAL CONDITION AT NO COST TO THE OWNER.
 13. CONTRACTOR RESPONSIBLE FOR MAINTAINING EXISTING UTILITY SERVICES (ELECTRICAL, SANITARY, STORM) DURING CONSTRUCTION UNLESS OTHERWISE SHOWN ON THE PLANS.
 14. CONTRACTOR SHALL COORDINATE ALL WORK SO PUBLIC SIDEWALK REMAINS OPEN THROUGHOUT CONSTRUCTION UNLESS OTHERWISE SHOWN ON THE PLANS.
 15. REFER TO ARCHITECTURE, CIVIL, AND ELECTRICAL PLANS FOR ADDITIONAL UTILITY ADJUSTMENTS AND REMOVALS.
 16. REFER TO SPECIFICATIONS FOR ADDITIONAL CONDITIONS, STANDARDS AND NOTES.

- ### SITE PREPARATION AND REMOVALS LEGEND
- | | |
|--|---|
| | REMOVE AND DISPOSE OF CONCRETE PAVING AND GRAVEL BASE. REMOVE SUBGRADE MATERIAL AS NEEDED. |
| | REMOVE AND DISPOSE OF ASPHALT PAVING AND GRAVEL BASE. REMOVE SUBGRADE MATERIAL AS NEEDED. |
| | REMOVE AND SALVAGE STONE WALLS, STEPS, AND PAVING. REMOVE SUBGRADE MATERIAL AS NEEDED. |
| | REMOVE LAWN AND MISCELLANEOUS SUBGRADE MATERIAL AS NEEDED. |
| | REMOVE ALL EXOTIC, INVASIVE, AND UNDESIRABLE PLANT SPECIES AS NOTED BY LANDSCAPE ARCHITECT. |
| | REMOVE WOOD DECK, POSTS, FOUNDATIONS AND BASE MATERIAL. REMOVE SUBGRADE MATERIAL AS NEEDED. |
| | TREE PROTECTION FENCE |
| | ITEM TO BE RELOCATED |
| | ITEM TO BE REMOVED |
| | CURB TO BE REMOVED |
| | LIMIT OF SAWCUT |
| | SILT FENCE |
| | CONSTRUCTION FENCE |
| | FENCE REMOVAL |
| | PROJECT LIMIT LINE |

assemble
design workshop

HARLEY CLARKE
MANSION
REHABILITATION &
ADAPTIVE REUSE

2603 SHERIDAN ROAD
EVANSTON, IL 60201

RVI

22 East Chicago Avenue
Suite 200
Naperville, IL 60540
T 630.961.1787
rviplanning.com

HARLEY CLARKE
DEVELOPMENT CO.

CLIENT/OWNER
CELADON CONSTRUCTION CORPORATION NFP

ARCHITECT OF RECORD
ASSEMBLE DESIGN WORKSHOP PLLC

STRUCTURAL ENGINEER
SRA STRUCTURAL ENGINEERS

MEP/FP ENGINEER
ARCHITECTURAL CONSULTING ENGINEERS

CIVIL ENGINEER
ENGAGE CIVIL, INC.

LANDSCAPE ARCHITECT
RVI PLANNING + LANDSCAPE ARCHITECTURE

HISTORIC PRESERVATION
RAMSEY HISTORIC CONSULTANTS, INC.

FOOD SERVICE CONSULTANT
TRIMARK MARLIN, LLC

LIGHTING DESIGN
MORLIGHTS, LLC

ELEVATOR CONSULTANT
JENKINS & HUNTINGTON, INC.

BUILDING ENVELOPE
REVIVE ARCHITECTURE, LLC

ACCESSIBILITY CONSULTANT
LCM ARCHITECTS

#	DESCRIPTION	DATE
02	CERT. OF APPROPRIATENESS	2026.06.17

**SITE PREPARATION
AND REMOVALS
ENLARGEMENT**

SCALE IN FEET
1" = 10'
NORTH 0' 5' 10' 20'

L2.01


© 2024 Assemble Design Workshop PLLC

LAYOUT NOTES

1. CONTRACTOR RESPONSIBLE FOR FIELD LAYOUT OF ALL NEW IMPROVEMENTS. DIGITAL FILES OF GEOMETRIC INFORMATION WILL BE PROVIDED UPON REQUEST IN AUTOCAD FORMAT. NO ADDITIONAL PAYMENT WILL BE MADE FOR ADJUSTMENTS NECESSARY TO CONSTRUCT THE WORK AS DRAWN.
2. CONTRACTOR RESPONSIBLE TO COORDINATE WORK IN ORDER TO OBTAIN APPROVAL OF ALL LAYOUT BY OWNERS REPRESENTATIVE PRIOR TO CONSTRUCTION. NO ADDITIONAL PAYMENT WILL BE MADE TO CORRECT WORK IF CONSTRUCTED INCORRECTLY WITHOUT PRE-APPROVAL BY OWNERS REPRESENTATIVE.
3. CONTRACTOR RESPONSIBLE TO MAINTAIN ALL LAYOUT STAKES DURING CONSTRUCTION. NO ADDITIONAL PAYMENT WILL BE MADE TO REPLACE LAYOUT STAKES.
4. PLACE STAKES AT EDGES OF SPORT COURTS, FIELDS, LIMITS OF PLAYGROUND, SHELTER, AND EVERY 25 FEET ON CENTER ALONG CENTERLINE OF ALL PATHWAYS FOR REVIEW BY THE OWNERS REPRESENTATIVE PRIOR TO EARTHWORK OPERATIONS.
5. ALL WALLS ARE DIMENSIONED TO FACE OF WALL UNLESS OTHERWISE NOTED.
6. ALL DIMENSIONS FROM ROADWAY ARE FROM BACK OF CURB UNLESS OTHERWISE NOTED.
7. ALL CURVES AND RADI TO BE SMOOTH AND NOT SEGMENTED.
8. CONTRACTOR TO PROVIDE LAYOUT STAKES EVERY 10 FEET MINIMUM FOR LARGE ARCS WHERE RADIUS POINTS ARE NOT ACCESSIBLE.
9. ADJUSTMENT TO STAKE LOCATIONS DUE TO DISCREPANCIES BETWEEN COORDINATES AND DIMENSIONS IS INCIDENTAL TO THE CONTRACT. NO ADDITIONAL PAYMENTS WILL BE MADE FOR THIS WORK.
10. ALL ROADWAY WIDTHS ARE MEASURED FROM EDGE OF PAVEMENT TO EDGE OF PAVEMENT UNLESS OTHERWISE SHOWN ON THE PLANS.
11. CONTRACTOR RESPONSIBLE TO TAKE DELIVERY, ASSEMBLE AND INSTALL ALL MATERIALS AND FURNISHINGS PER MANUFACTURER'S INSTRUCTIONS.
12. PLACE CONTROL AND EXPANSION JOINTS AS SHOWN ON PLANS AND DETAILS FOR ALL CURBS, WALKS, WALLS, STEPS, AND CONCRETE PAVING. WHERE JOINTS ARE NOT SHOWN, PLACE CONTROL JOINTS A MAXIMUM OF 10 FEET ON CENTER. EXPANSION JOINTS A MAXIMUM OF 30 FEET ON CENTER, AND BETWEEN ALL SEPARATE POURS.
13. CONTRACTOR WILL MAINTAIN USE ZONE REQUIREMENTS WITHIN SOFT SURFACING. NO USE ZONE WILL OVERLAP OR BE TANGENT UNLESS NOTED. ADJUST PLAYGROUND BARRIER CURB AND/OR ADJACENT PAVING AS NEEDED TO ACCOMMODATE PLAY EQUIPMENT FALL ZONES.
14. COORDINATE LOCATION OF STORM LINE WITH PLAYGROUND FOOTINGS AND OBTAIN OWNER'S APPROVAL PRIOR TO INSTALLATION.
15. LAYOUT OF SOFT SURFACE SHALL BE VERIFIED IN FIELD BY LANDSCAPE ARCHITECT.
16. REFER TO SPECIFICATIONS FOR ADDITIONAL CONDITIONS, STANDARDS AND NOTES.

LAYOUT LEGEND

- | | |
|----|--|
| EJ | EXPANSION JOINT |
| PC | POINT OF CURVE |
| PT | POINT OF TANGENCY |
| | STONE PAVING |
| | PATIO PAVING |
| | GRAVEL PAVING |
| | P.C.C. SIDEWALK, 5 INCH, WITH AGGREGATE BASE |
| | RELOCATED STEPPING STONE |

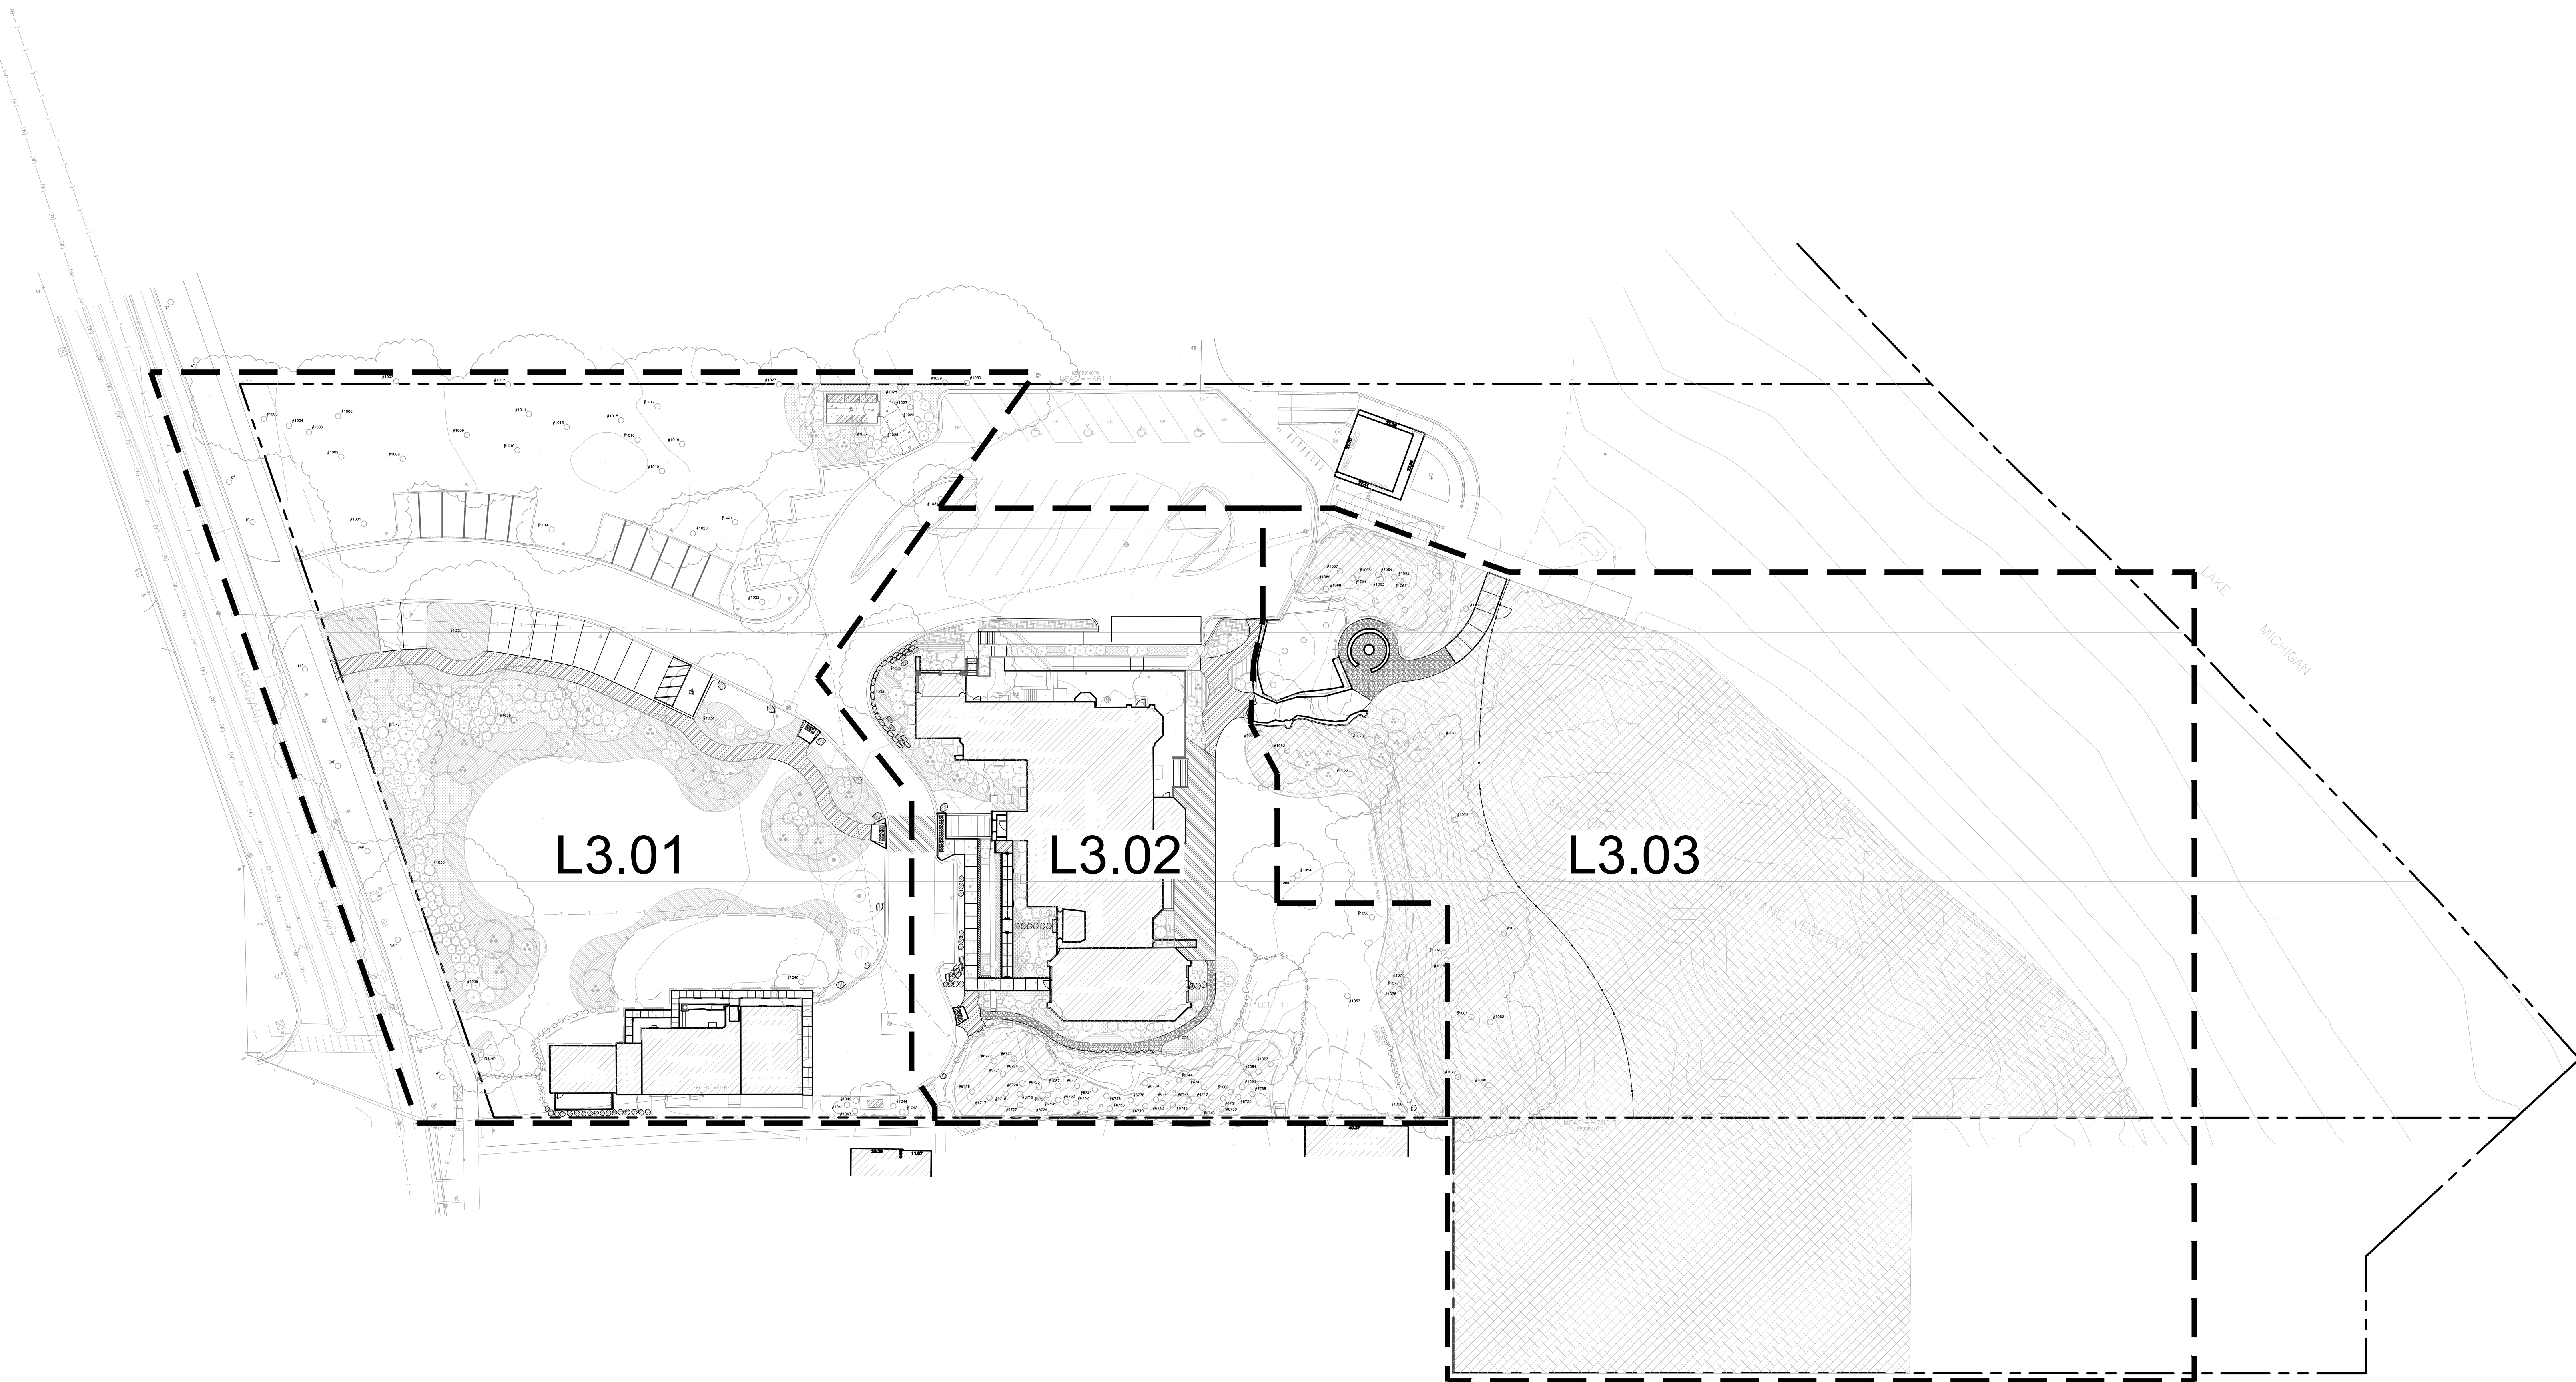

PROFESSIONAL OF RECORD

LICENSE EXP. MM/DD/YYYY

PROJECT NUMBER: 250401

SHEET NAME

 
LAYOUT AND
MATERIALS PLAN

SCALE IN FEET
1" = 30'
NORTH 0' 15' 30' 60'

SHEET NUMBER

L3.00


© 2024 Assemble Design Workshop PLLC



- ### LAYOUT LEGEND
- | | |
|---|--|
| EJ | EXPANSION JOINT |
| PC | POINT OF CURVE |
| PT | POINT OF TANGENCY |
|  | STONE PAVING |
|  | PATIO PAVING |
|  | GRAVEL PAVING |
|  | P.C.C. SIDEWALK, 5 INCH, WITH AGGREGATE BASE |
|  | RELOCATED STEPPING STONE |

SHEET NAME

SHEET NUMBER

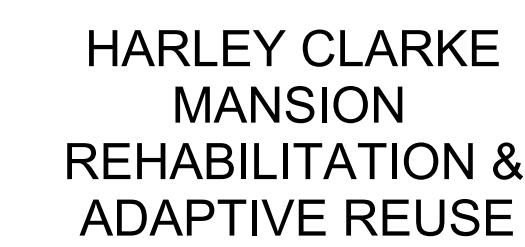

RVi


**HARLEY
CLARKE**
DEVELOPMENT CO.

ACCESSIBILITY CONSULTANT
LCM ARCHITECTS

LAYOUT AND

L3.03

© 2024 Assembly Design Workshop PLLC

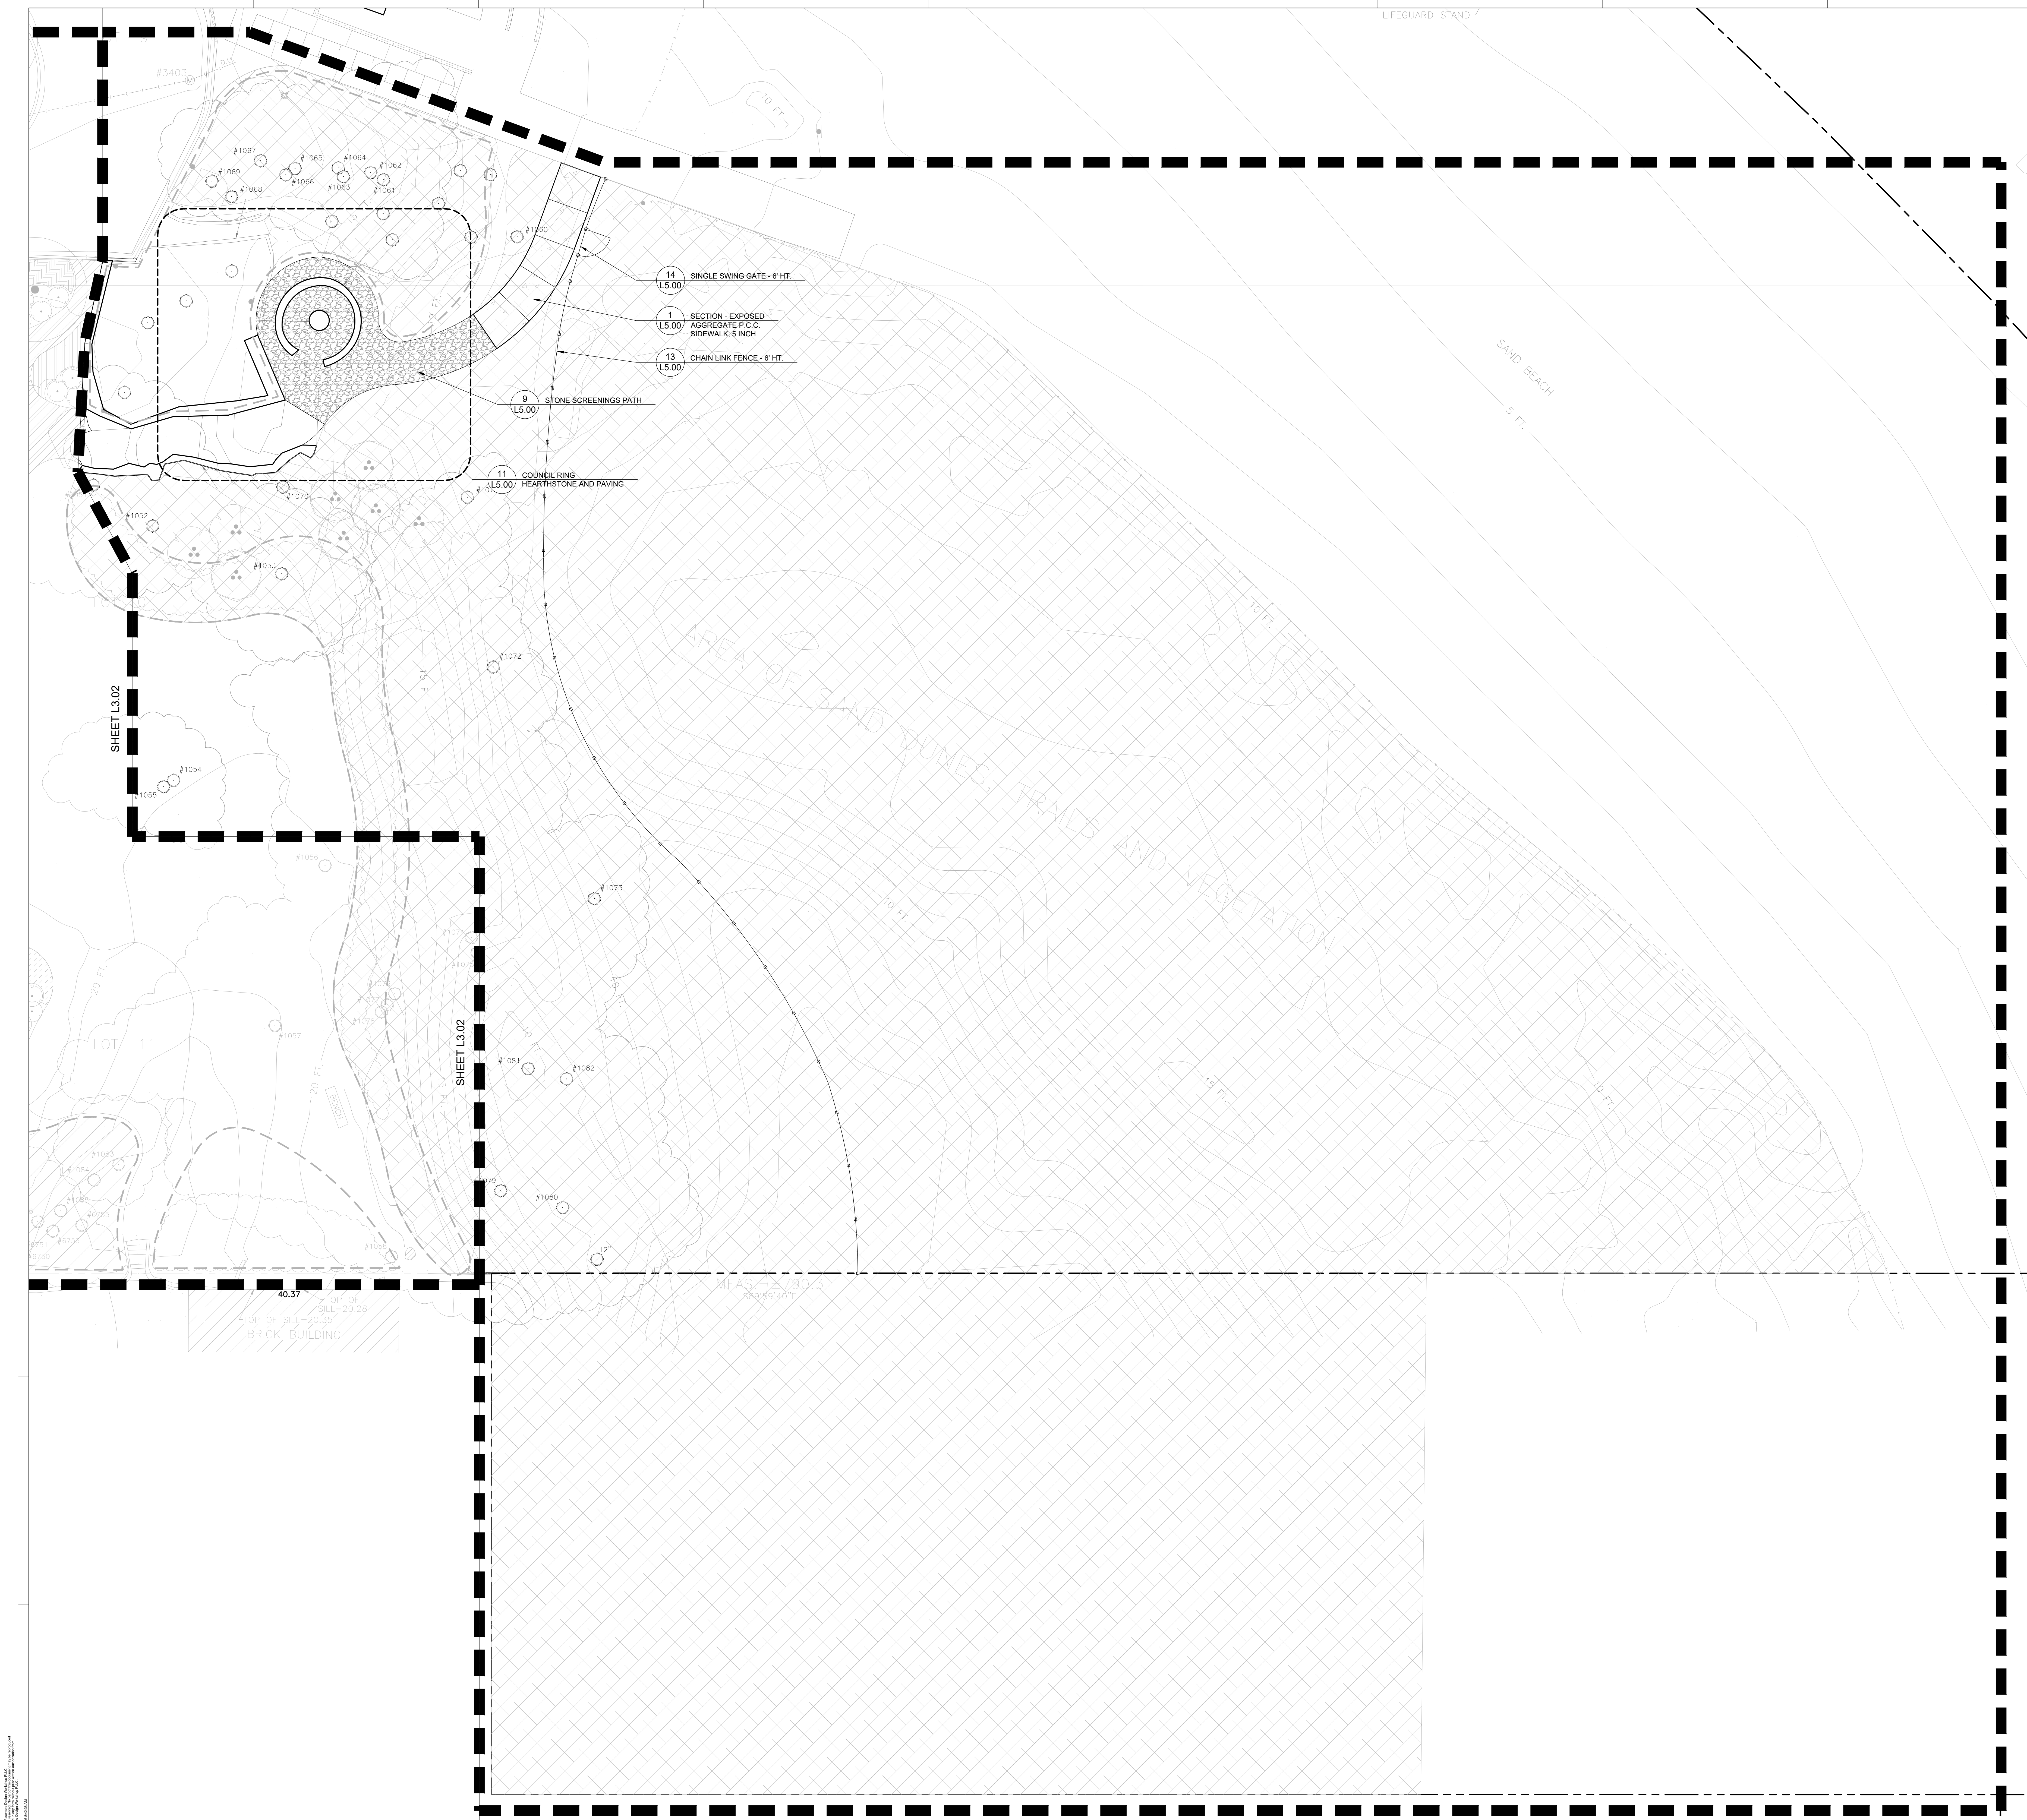

PROFESSIONAL OF RECORD

LICENSE EXP. MM.DD.YYYY

PROJECT NUMBER: 250401

LANDSCAPE
PLAN

SCALE IN FEET


$1'' = 3$

NORTH	0'	15'	30'	6
-------	----	-----	-----	---

L4.00


© 2024 Assembly Design Workshop PLLC

 ©2008 Associates Design's Marketing, PLLC
rights reserved. No part of this document may be reproduced
without prior written permission from
Associates Design's Marketing, PLLC.



- ### PLANTING LEGEND
- | | |
|---|--|
|  | SHADE TREE, TYPICAL.
SEE DETAIL FOR INSTALLATION. |
|  | ORNAMENTAL TREE, TYPICAL.
SEE DETAIL FOR INSTALLATION. |
|  | EVERGREEN TREE, TYPICAL.
SEE DETAIL FOR INSTALLATION. |
|  | SHRUB AREA, TYPICAL.
SEE DETAIL FOR INSTALLATION. |
|  | PERENNIAL AND GROUNDCOVER AREA,
TYPICAL. SEE DETAIL FOR INSTALLATION. |
|  | LAWN |
|  | NO-MOW, SEE SPECIFICATIONS |
|  | NATURAL AREA RESTORATION |

R Asanbide Design/Workshop PLLC

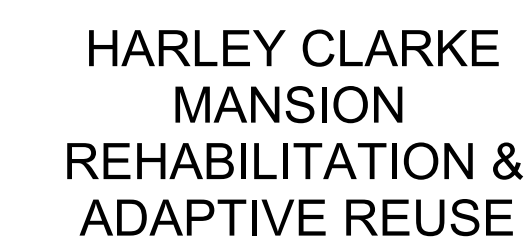

RVi

**HARLEY
CLARKE**
DEVELOPMENT CO.


LCM ARCHITECTS

LICENSE EXP. MM.DD.YYYY


TABLE 1

L4.03


© 2009 Assembly Design Workshop PLLC

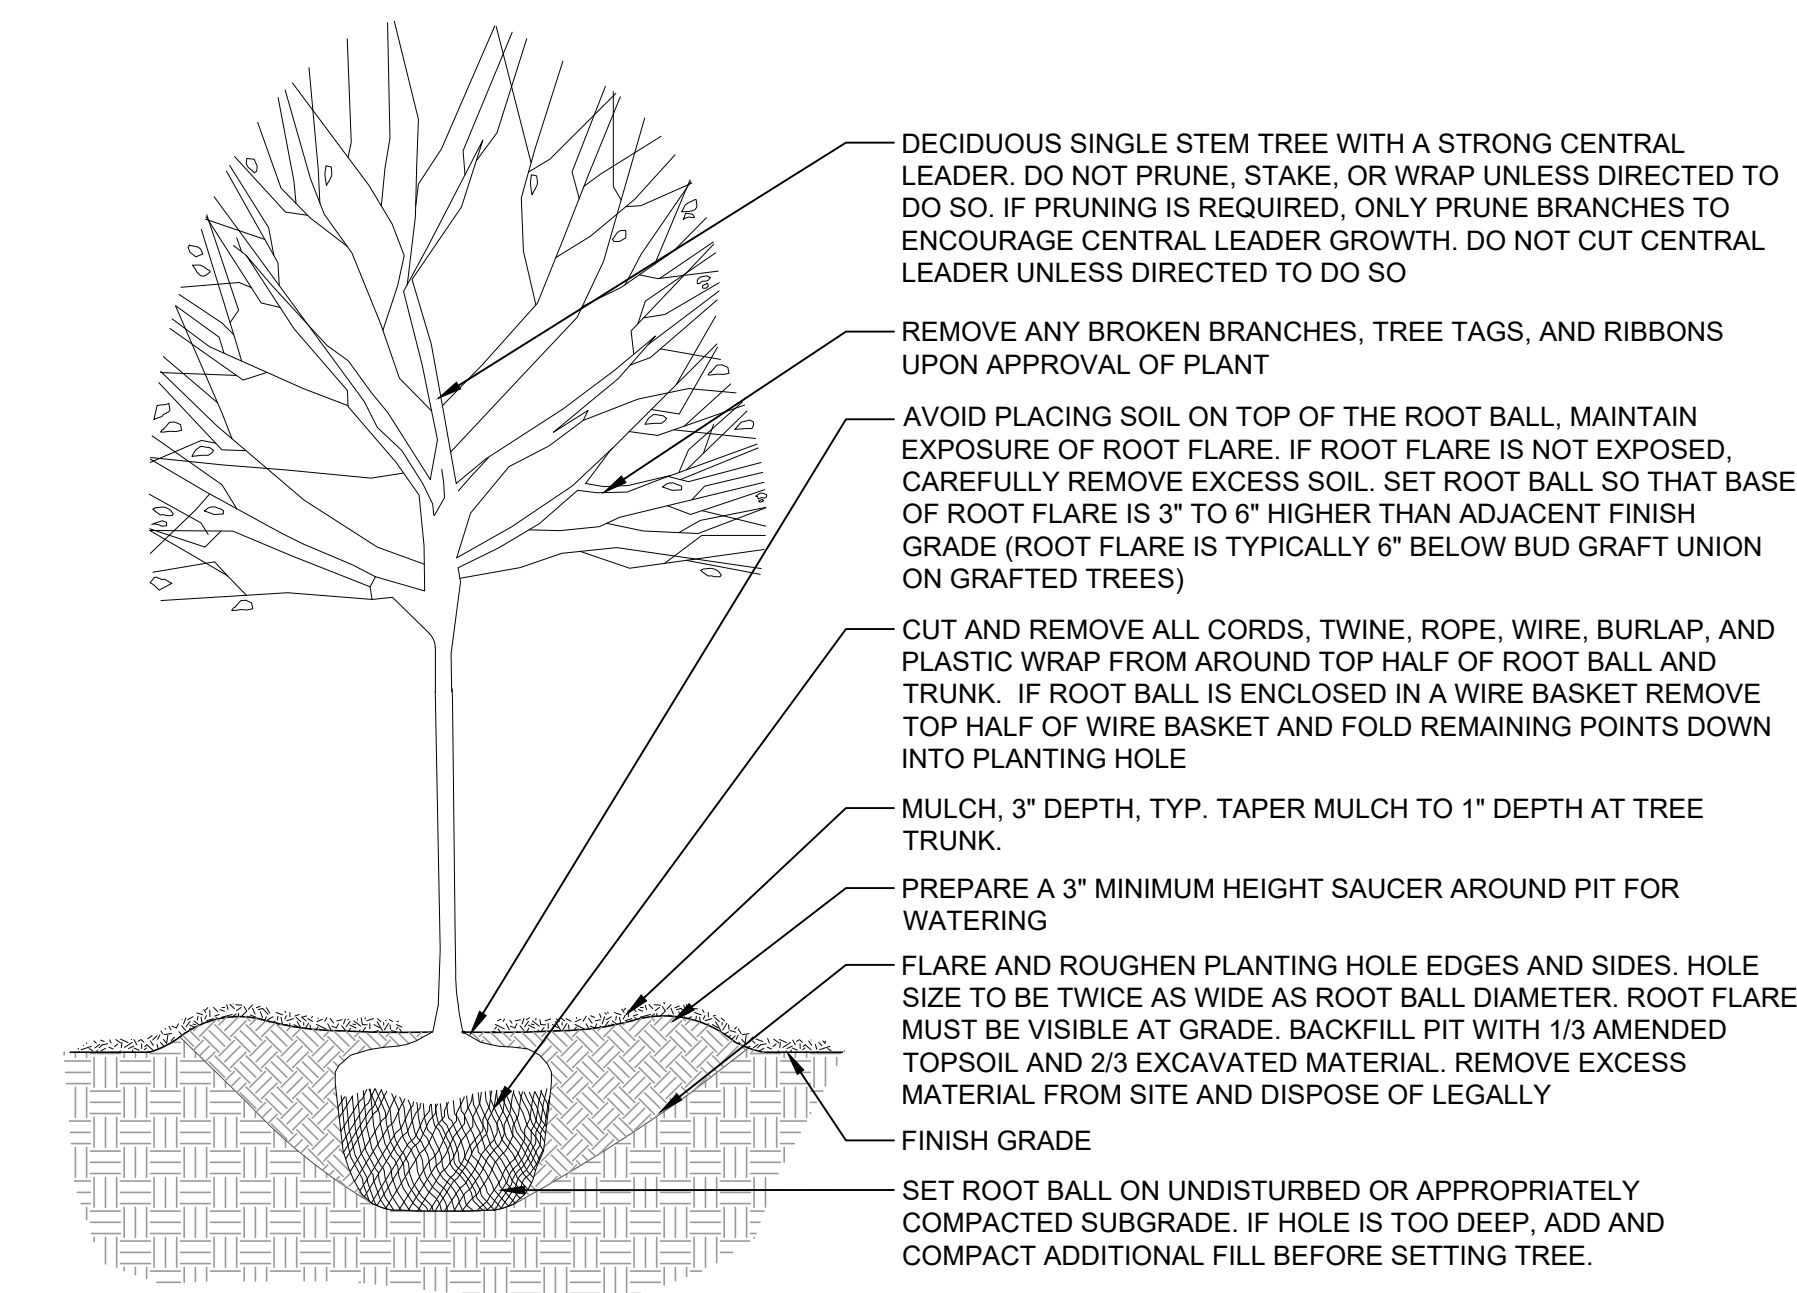


1 SINGLE STEM TREE PLANTING
1/2" = 1'-0"

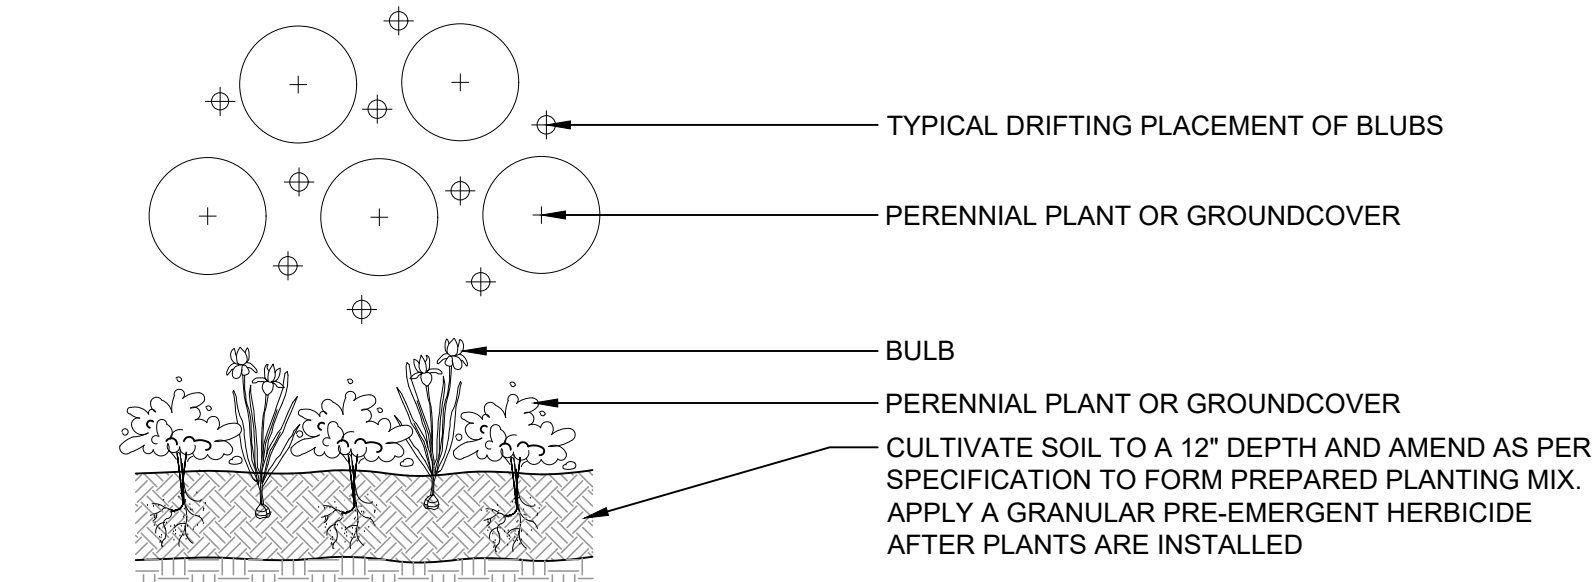


5 BULB PLANTING DETAIL
1/2" = 1'-0"

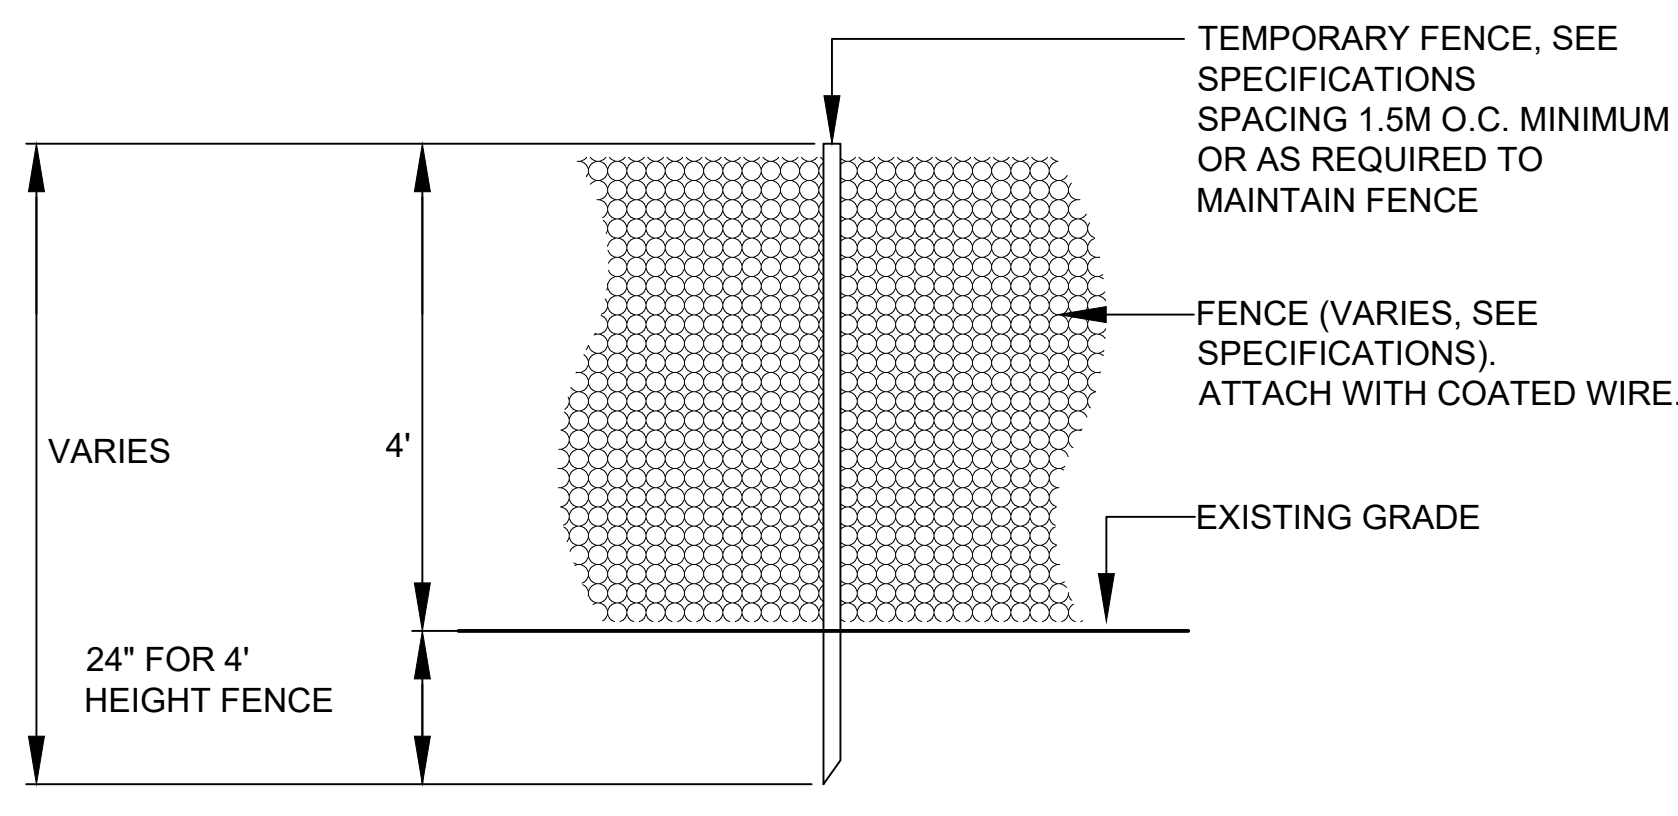


9 TYP. TREE PROTECTION FENCE
NTS

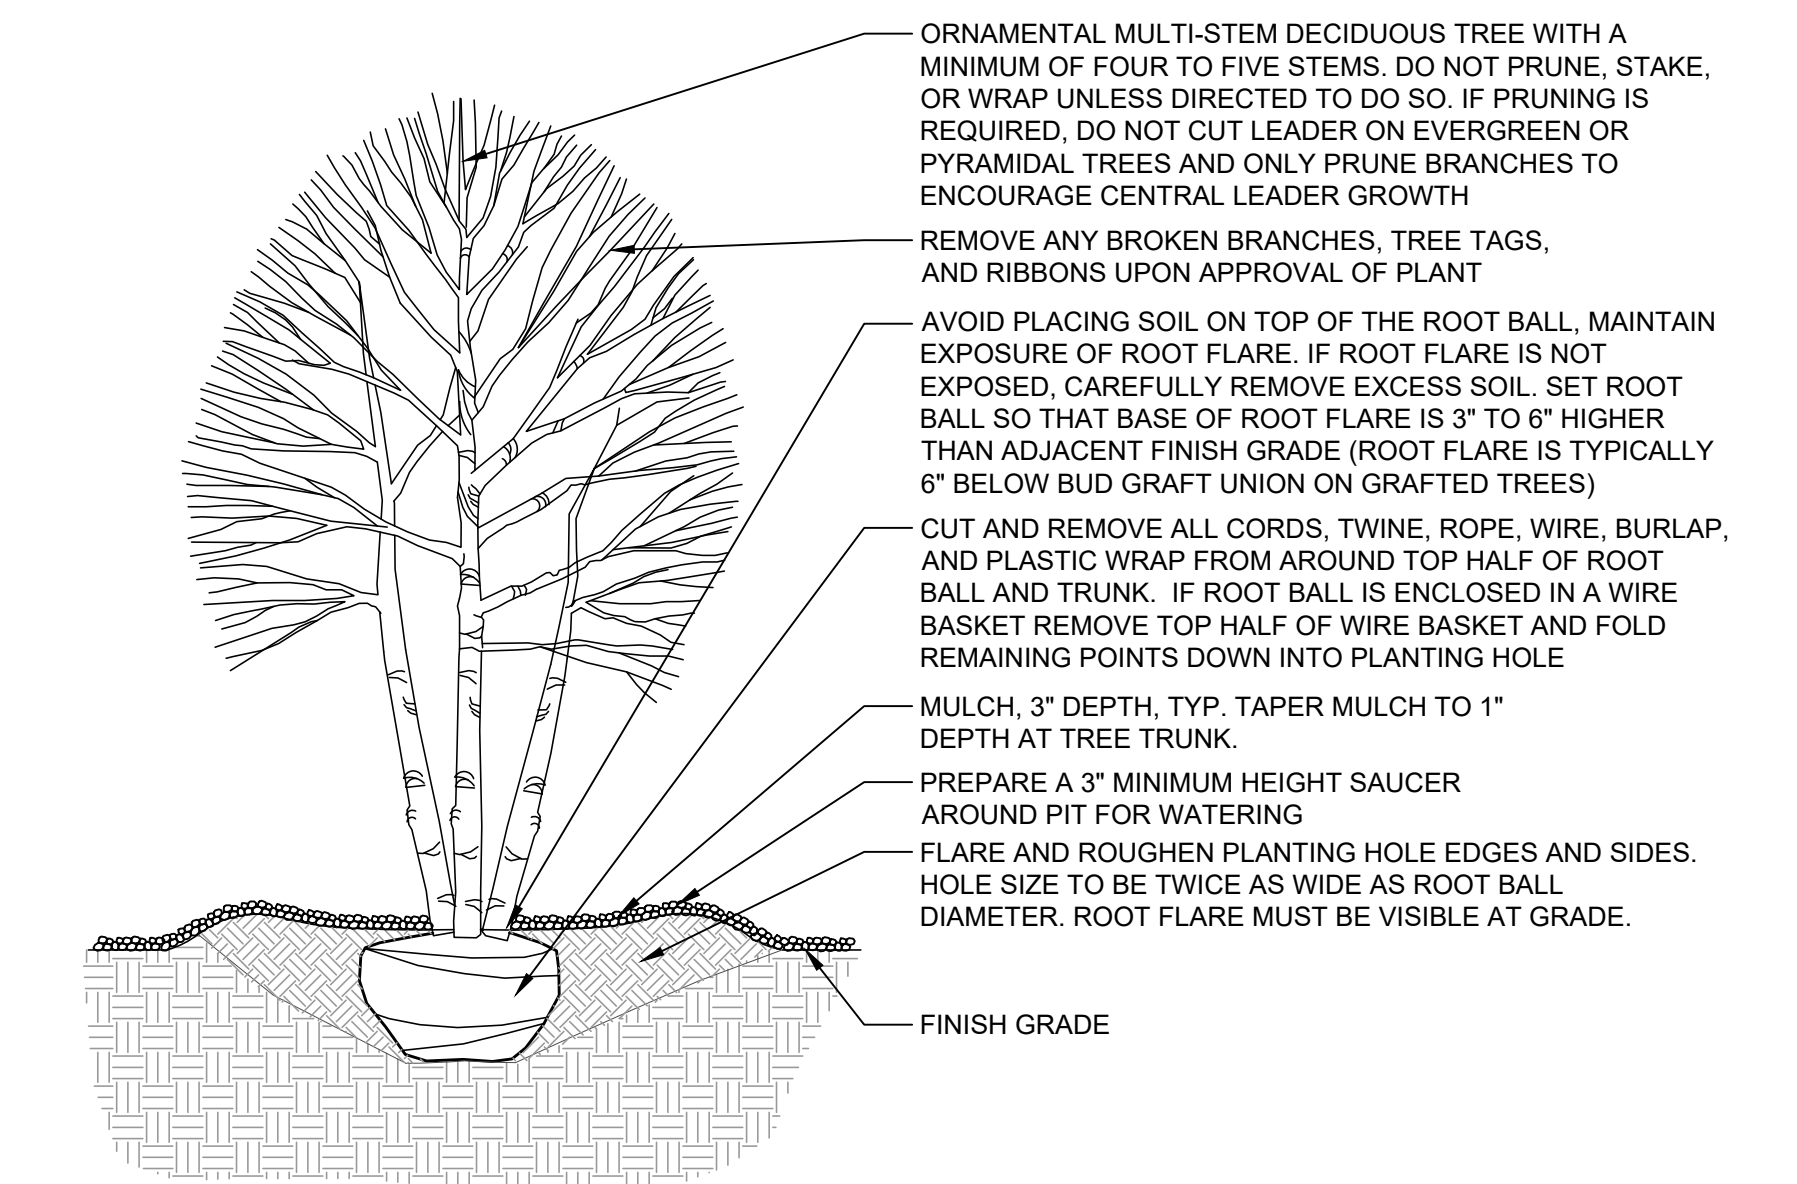


2 MULTI-STEM TREE PLANTING
1/2" = 1'-0"

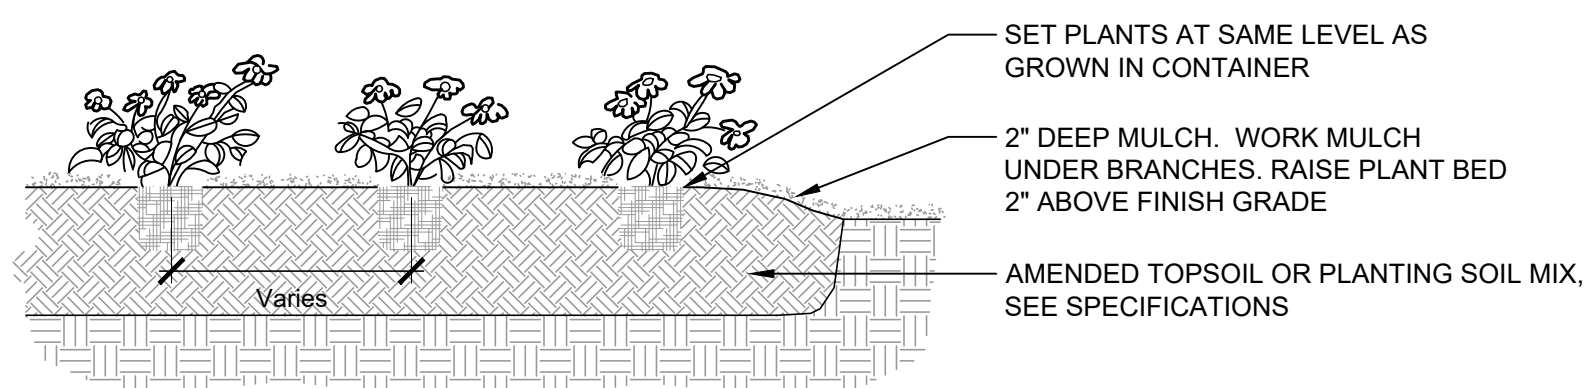


6 PERENNIAL AND GROUNDCOVER PLANTING
1/2" = 1'-0"

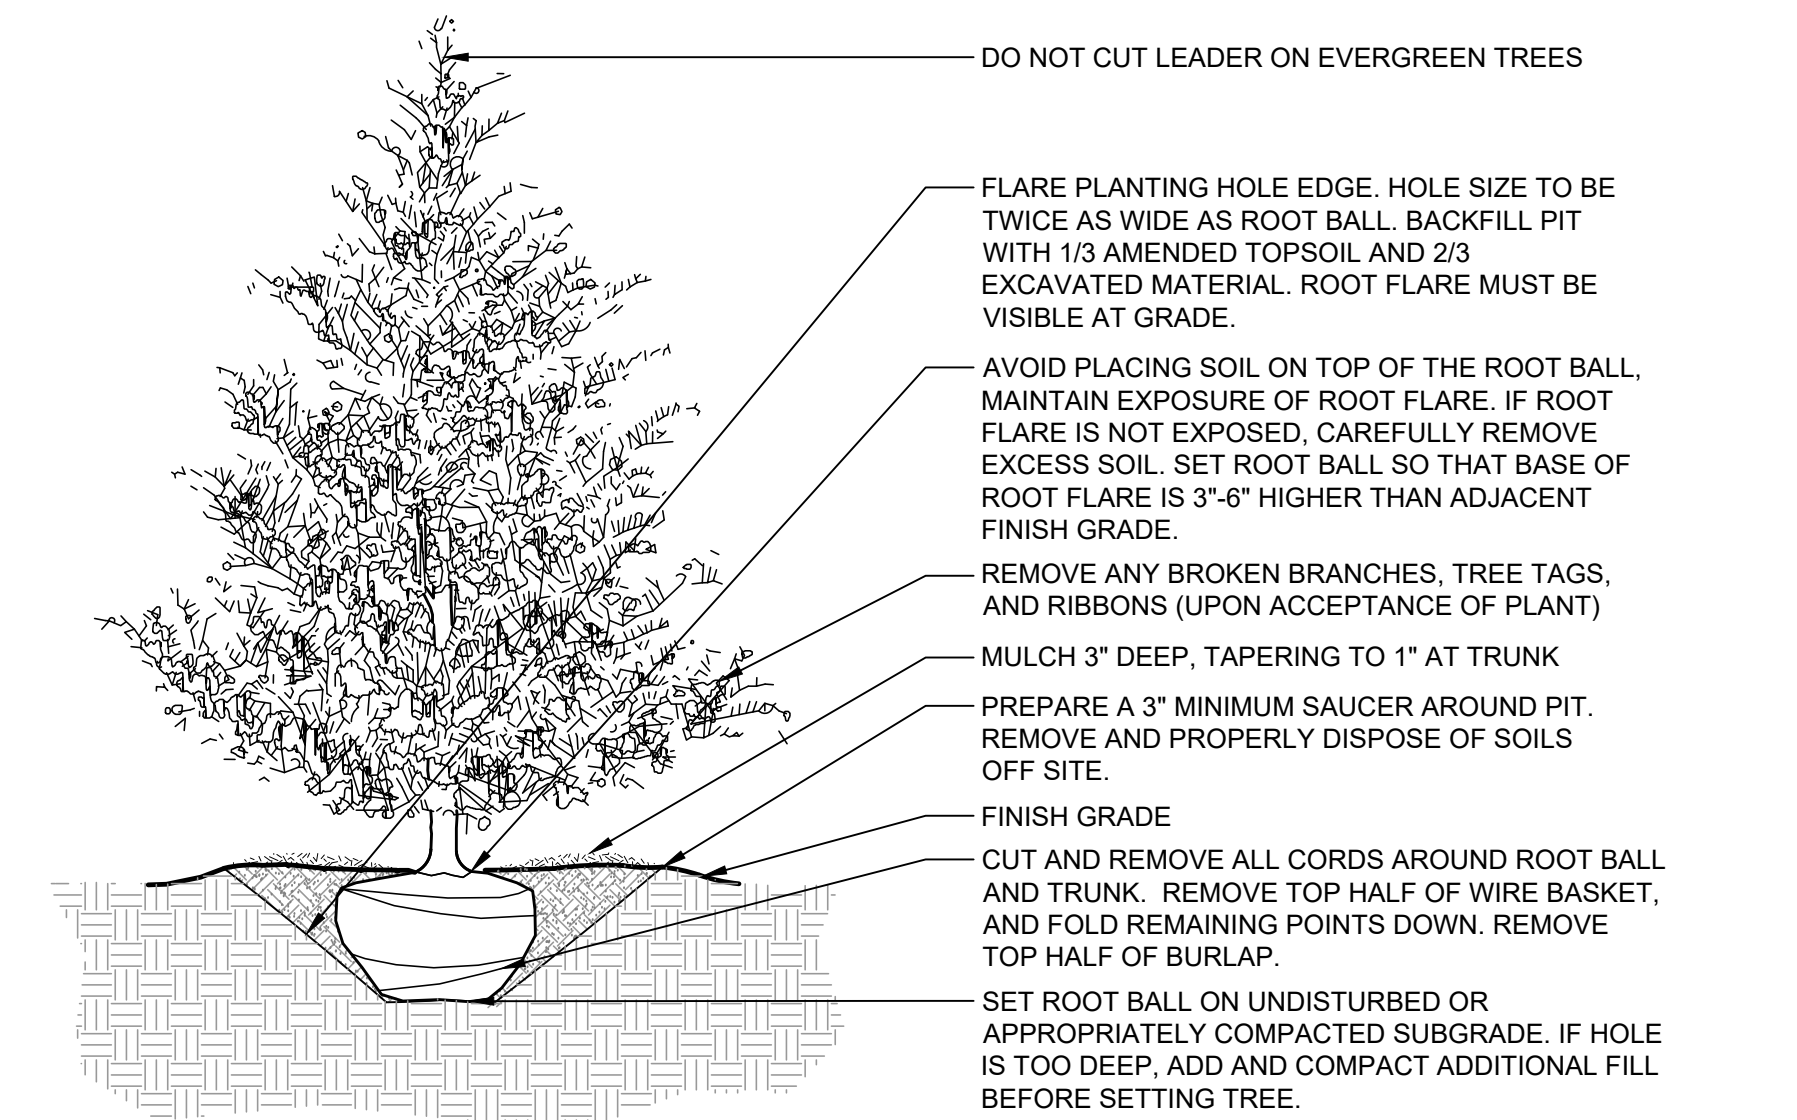


3 EVERGREEN TREE PLANTING
1/2" = 1'-0"

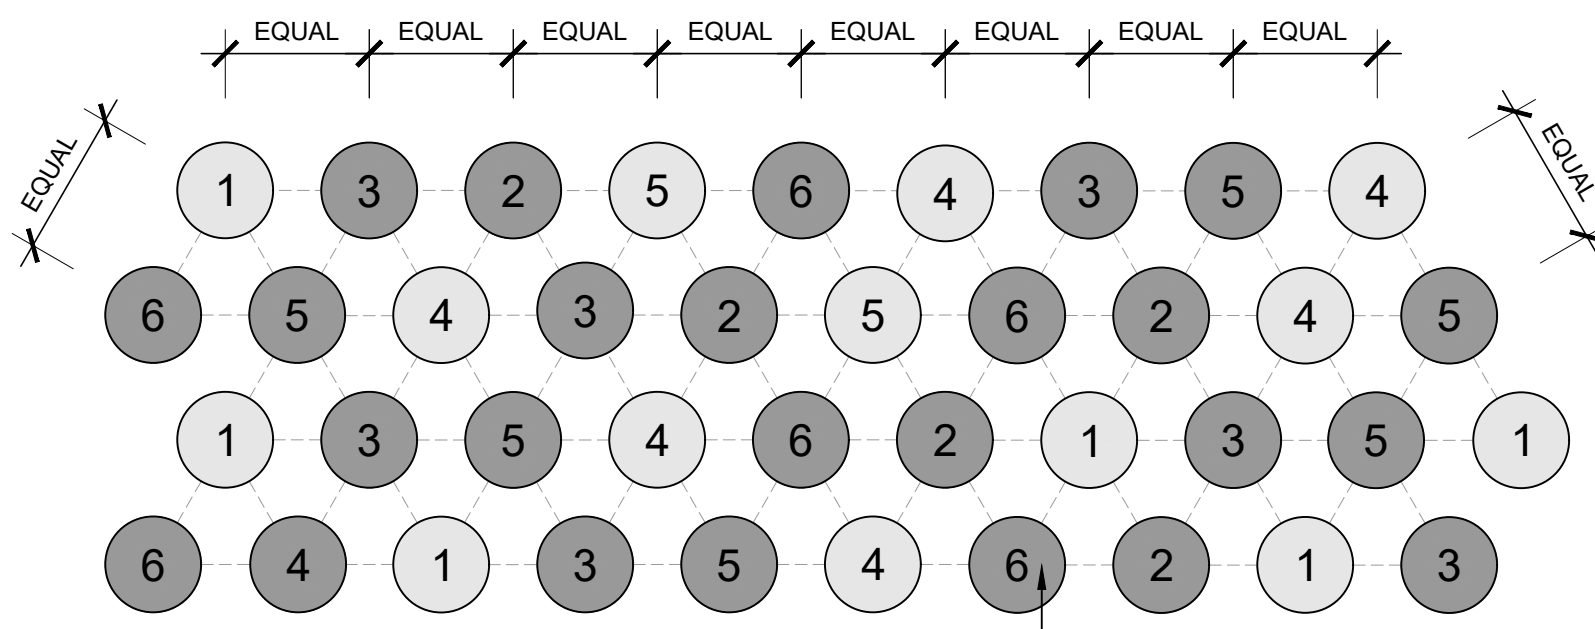

7 PLANT SPACING
1/2" = 1'-0"

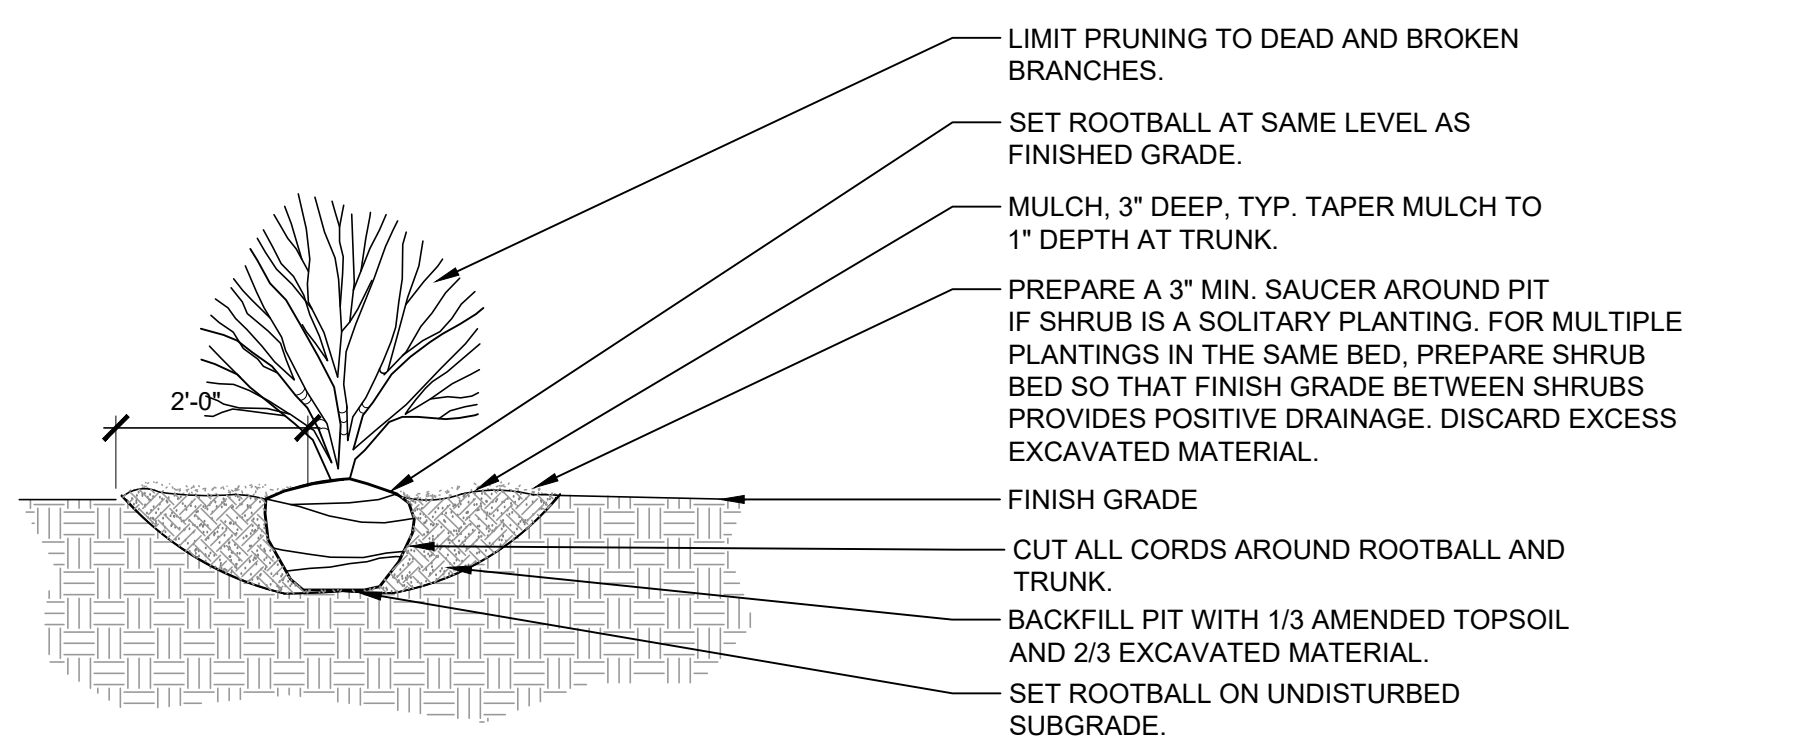

4 SHRUB PLANTING
1/2" = 1'-0"

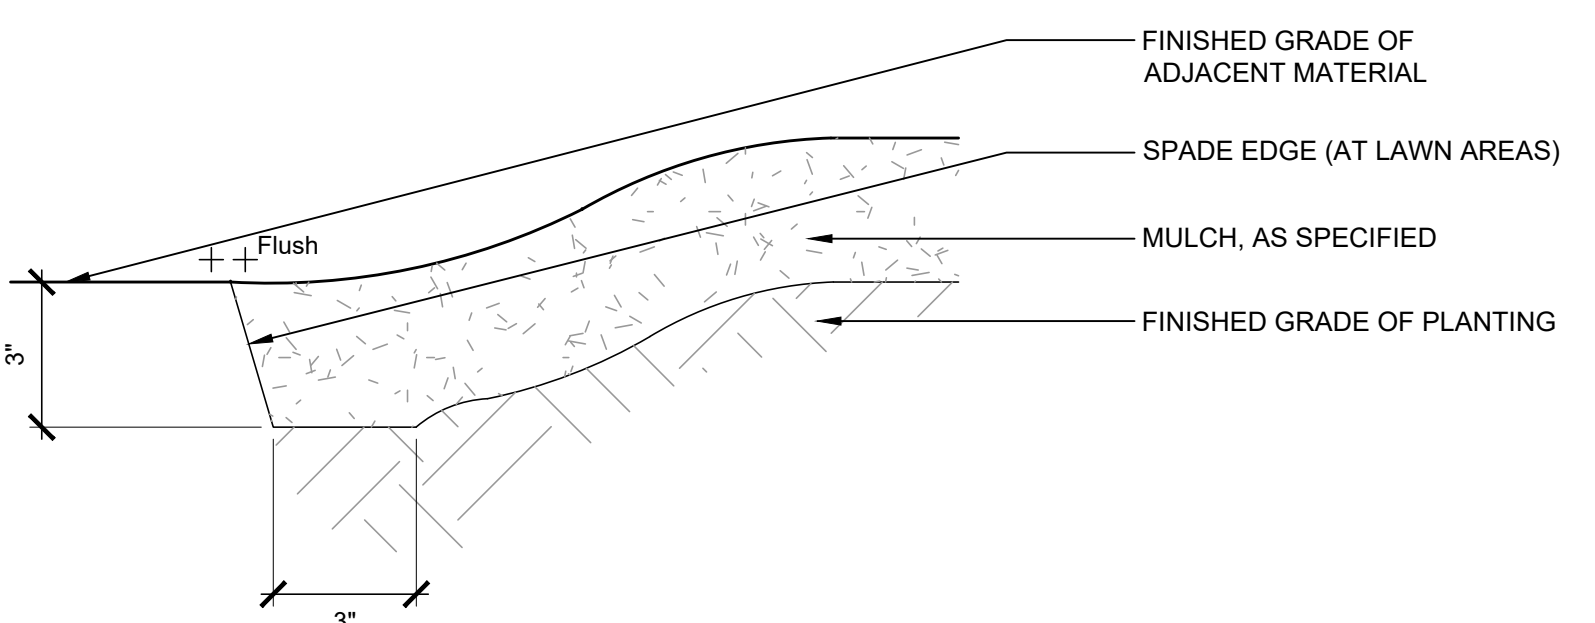

8 PLANTING BED EDGE
3" = 1'-0"

PLANT SCHEDULE					
CODE	BOTANICAL NAME	COMMON NAME	SIZE		QTY
DECIDUOUS TREES					
AFT	Acer saccharum 'Ballista'	Fall Fiesta® Sugar Maple	3" Cal		2
UAJ	Ulmus americana 'Jefferson'	Jefferson American Elm	3" Cal		4
UAP	Ulmus americana 'Princeton'	Princeton American Elm	3" Cal		5
ORNAMENTAL TREE					
AEA	Amelanchier arborea	Downy Serviceberry	8' Ht.		1
CCA	Carpinus caroliniana	American Hornbeam	3" Cal		1
CCD	Cercis canadensis	Eastern Redbud Multi-trunk	6' Ht.		3
CCG	Crataegus crus-galli	Cockspur Hawthorn	3" Cal		6
HVE	Hamamelis vernalis	Osark Witchhazel	6' Ht.		5
HVI	Hamamelis virginiana	Common Witch Hazel	6' Ht.		8
IKB	Malus ioensis 'Kiehm's Bechtel'	Kiehm's Improved Bechtel Crabapple	3" Cal		2
IMC	Malus ioensis 'Prairie Rose'	Prairie Rose Crabapple	3" Cal		7
PMI	Prunus americana	American Plum	1.5" Cal.		3
DECIDUOUS SHRUBS					
AWM	Aronia melanocarpa 'Morton'	Iroquois Beauty Black Chokeberry	36" Ht.		33
COY	Corylus americana	American Hazelnut	5 Gal.		9
DLO	Diervilla lonicera	Bush Honeysuckle	3 Gal.		78
DKR	Diervilla x 'COZY85411'	Kodiak® Red Diervilla	36" Ht.		48
HAN	Hydrangea arborescens 'Annabelle'	Annabelle Smooth Hydrangea	24" Ht.		13
HHH	Hydrangea arborescens 'Halo'	Halo® Halo Smooth Hydrangea	3 Gal.		63
PFM	Paconia x 'Festiva Maxima'	Festiva Maxima Double Peony	2 Gal.		3
PBL	Philadelphus lewisii 'Blizzard'	Blizzard Mock Orange	-		10
PHO	Physocarpus opulifolius	Ninebark	36" Ht.		12
RNO	Rosa x 'NOA160980'	Flower Carpet® Pink Supreme Groundcover Rose	3 Gal.		16
RXS	Rosa x 'SRPylwko'	Easy Bee-zy™ Knock Out® Rose	3 Gal.		1
SXP	Syringa x pubescens 'SMNSPWF'	Bloomerang Showmound™ Lilac	24" Ht.		6
VDE	Viburnum dentatum	Viburnum	3" Cal		27
VDH	Viburnum dentatum 'Blue Muffin'	Blue Muffin Arrowwood Viburnum	24" Ht.		6
VNB	Viburnum lentago	Nannyberry	5 Gal.		7
CODE BOTANICAL NAME COMMON NAME CONTAINER SPACING QTY					
GRASSES					
BCU	Beckluea curtipendula	Side Oats Grama	1 Gal.	18" o.c.	53
CAK	Calamagrostis x acutiflora 'Karl Foerster'	Karl Foerster Feather Reed Grass	1 gal	24" o.c.	13
CPE	Carex pensylvanica	Pennsylvania Sedge	1 gal	18" o.c.	383
CPI	Carex plantaginea	Plantain-leaved Sedge	1 gal	18" o.c.	248
SHE	Sporobolus heterolepis	Prairie Dropseed	1 gal	18" o.c.	93
PERENNIALS					
ACE	Allium cernuum	Nodding Onion	1 gal	18" o.c.	76
AND	Anemone canadensis	Canadian Anemone	1 gal	18" o.c.	171
ADC	Aquilegia canadensis	Eastern Columbine	1 gal	18" o.c.	115
AFF	Athyrium filix-femina	Common Lady Fern	1 Gal.	15" o.c.	46
EHV	Elymus hystrix	Bottlebrush Grass	1 gal	18" o.c.	192
ELM	Elyria macrophylla	Digleaf Aster	1 gal	18" o.c.	344
EDJ	Eutrochium dubium 'Little Joe'	Little Joe Pye Weed	1 Gal.	18" o.c.	10
GMA	Geranium maculatum	Wild Cranesbill Geranium	1 gal	18" o.c.	410
HRO	Hemerocallis x 'Rosy Returns'	Rosy Returns Daylily	1 gal	15" o.c.	27
ISC	Iris sibirica 'Butter & Sugar'	Butter and Sugar Siberian Iris	1 Gal.	18" o.c.	3
ISU	Iris sibirica 'Caesar's Brother'	Caesar's Brother Siberian Iris	1 Gal.	18" o.c.	3
LSN	Leucanthemum x superbum 'Snowcap'	Snowcap Shasta Daisy	1 Gal.	12" o.c.	48
OCI	Osmunda cinnamomea	Cinnamon Fern	1 Gal.	15" o.c.	46
PEO	Penstemon digitalis	Foxglove Beardtongue	1 gal	18" o.c.	62
PHD	Phlox divaricata	Woodland Phlox	1 gal	18" o.c.	258
POA	Polystichum acrostichodes	Christmas Fern	1 Gal.	15" o.c.	46
RSV	Rudbeckia fulgida speciosa 'Viette's Little Suzy'	Viette's Little Suzy Coneflower	1 gal	18" o.c.	101
SOC	Solidago caesia	Bluestem Goldenrod	1 gal	18" o.c.	115
SFL	Solidago flexuosa	Zigzag Goldenrod	1 Gal.	18" o.c.	115
SSG	Solidago sphacelata 'Golden Fleece'	Golden Fleece Autumn Goldenrod	1 Gal.	18" o.c.	32
SMA	Spigelia marilandica	Indian Pink	1 Gal.	12" o.c.	45
SOB	Symphoricarpon oblongifolium	Aromatic Aster	1 gal	18" o.c.	32
SOT	Symphoricarpon oblongifolium 'October Skies'	October Skies Aromatic Aster	1 gal	18" o.c.	14
THD	Thalictrum dioicum	Early Meadow Rue	1 Gal.	18" o.c.	115
TRO	Tradescantia virginica	Ohio Spiderwort	1 gal	18" o.c.	115
VWB	Veronica x 'Blue Sprite'	Blue Sprite Speedwell	1 Gal.	18" o.c.	115
VWA	Vinca minor 'Atropurpurea'	Purple Periwinkle	3" Pot	12" o.c.	109